


5TH AVENUE

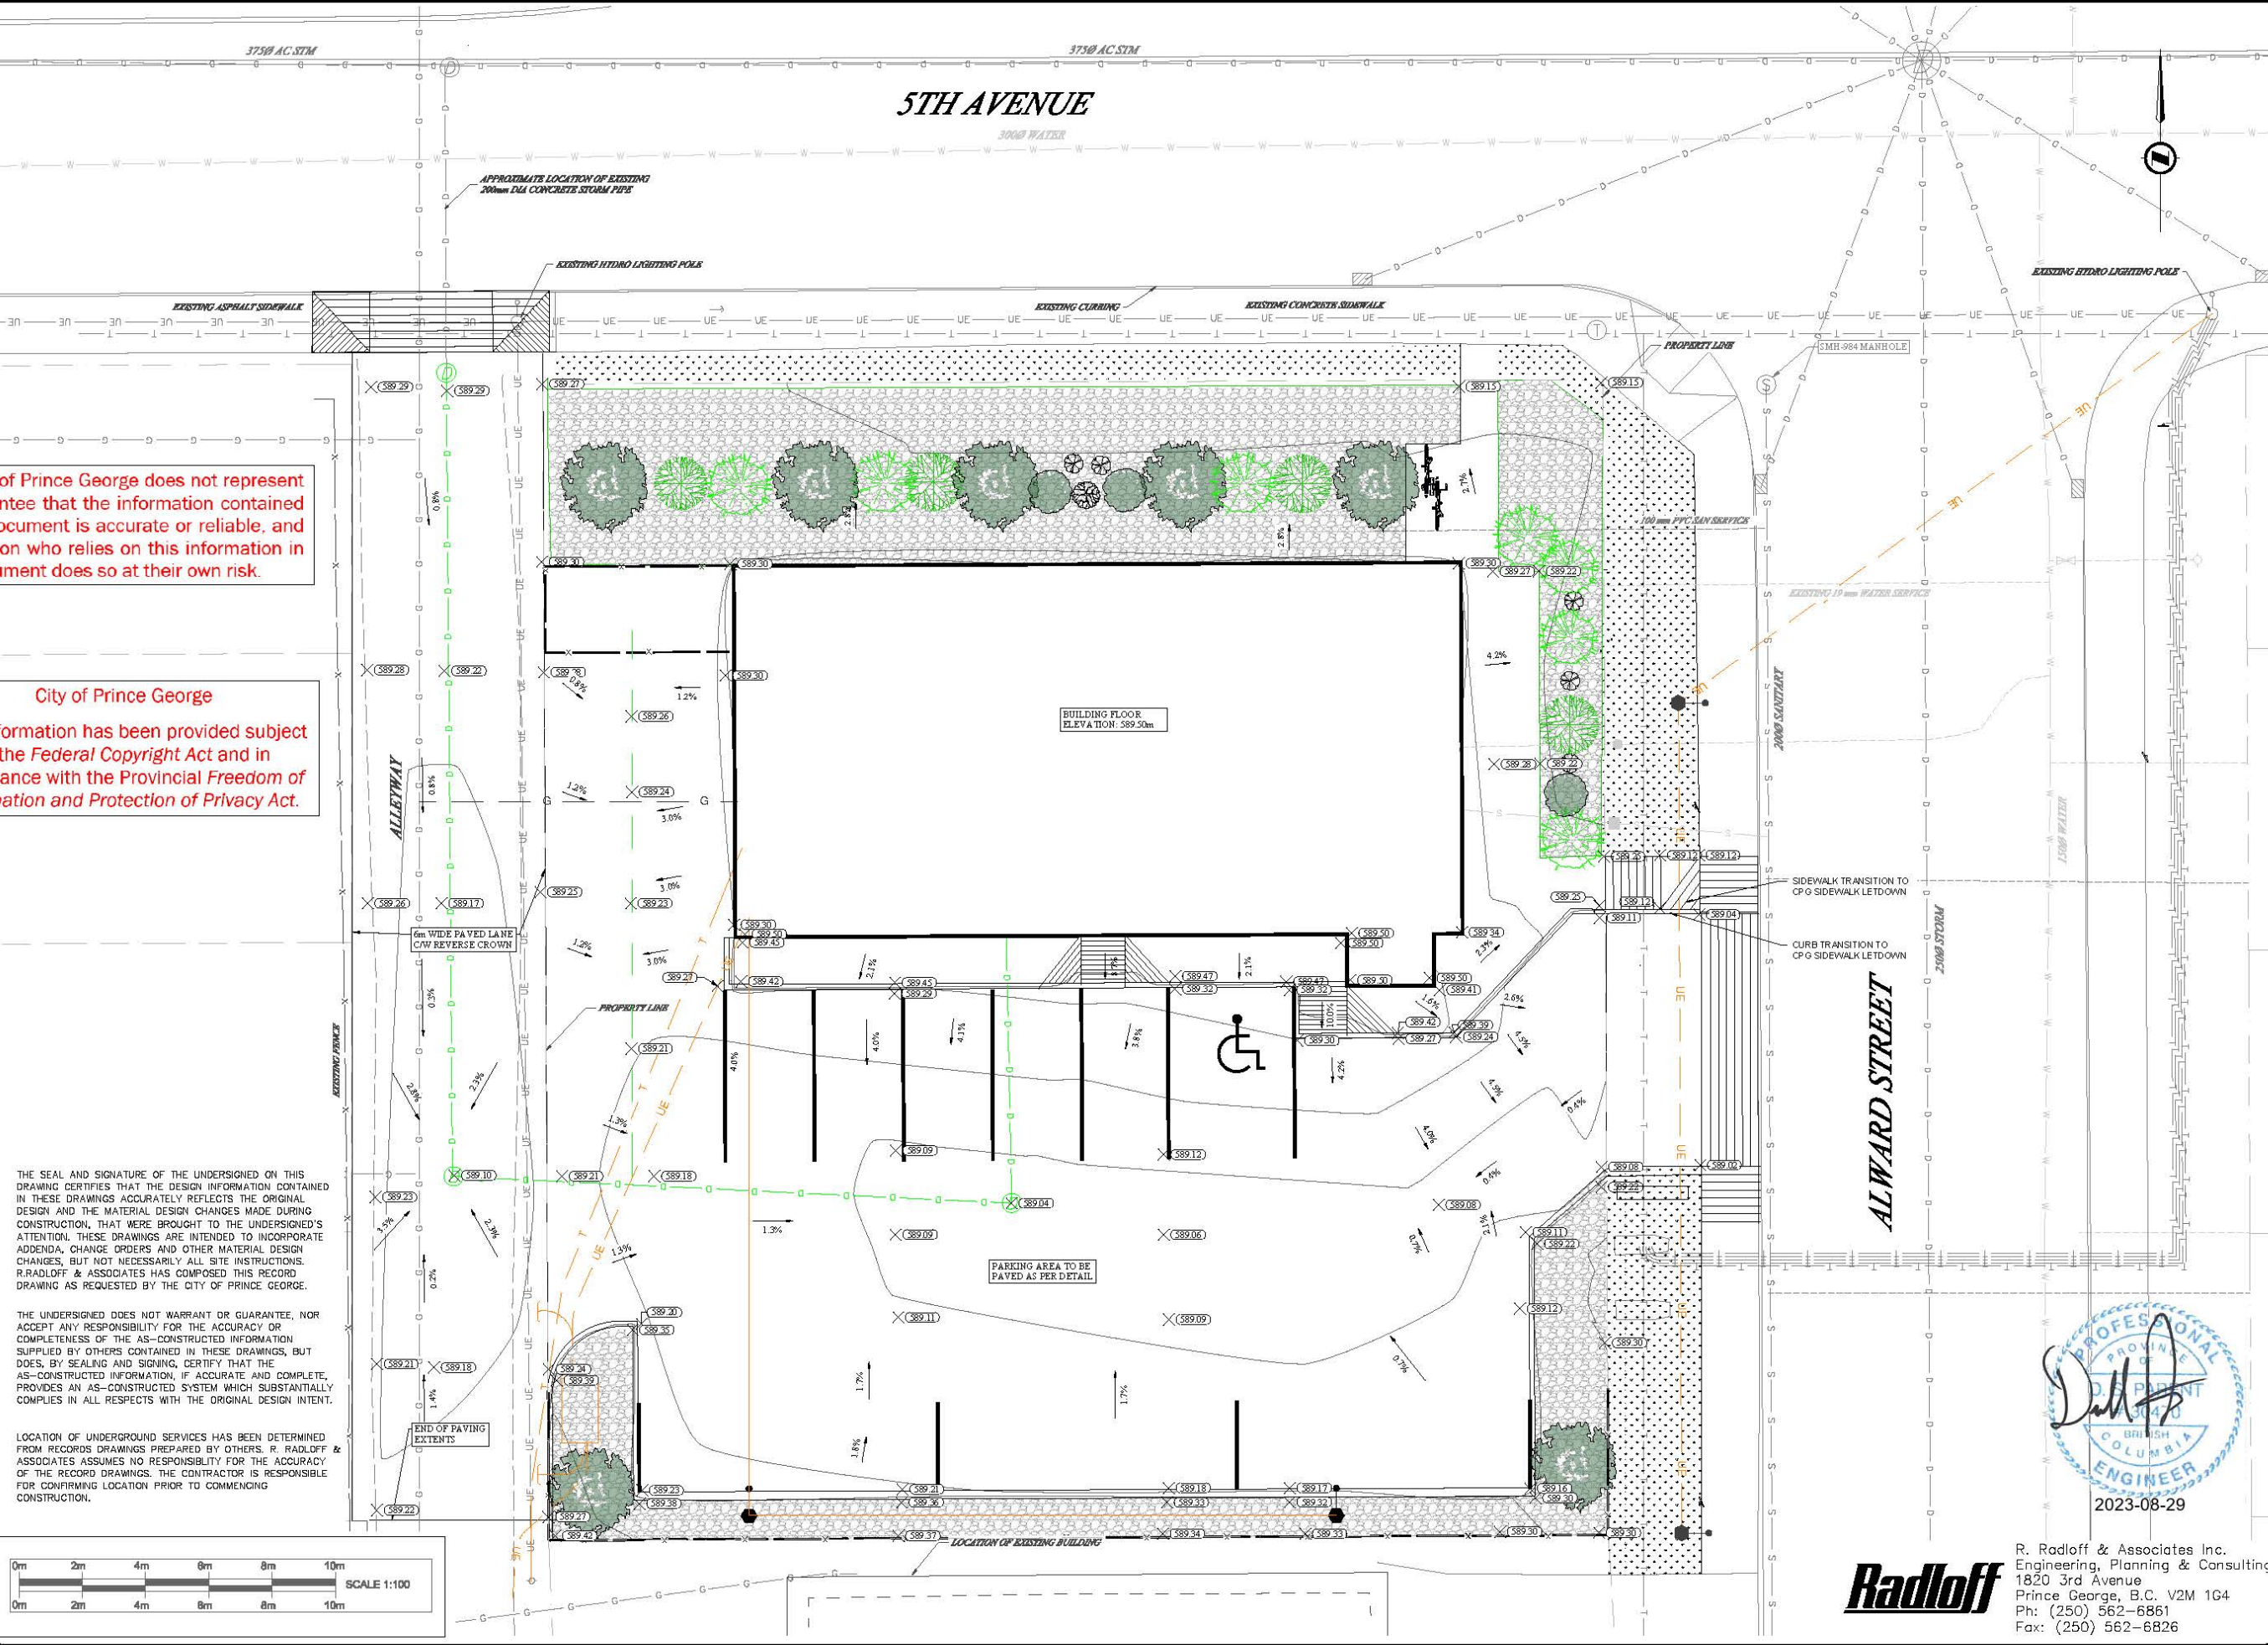

 
The City of Prince George does not represent or guarantee that the information contained in this document is accurate or reliable, and any person who relies on this information in this document does so at their own risk.

City of Prince George
This information has been provided subject to the Federal Copyright Act and in accordance with the Provincial Freedom of Information and Protection of Privacy Act.

THE SEAL AND SIGNATURE OF THE UNDERSIGNED ON THIS DRAWING CERTIFIES THAT THE DESIGN INFORMATION CONTAINED IN THESE DRAWINGS ACCURATELY REFLECTS THE ORIGINAL DESIGN AND THE MATERIAL DESIGN CHANGES MADE DURING CONSTRUCTION, THAT WERE BROUGHT TO THE UNDERSIGNED'S ATTENTION. THESE DRAWINGS ARE INTENDED TO INCORPORATE ADDENDA, CHANGE ORDERS AND OTHER MATERIAL DESIGN CHANGES, BUT NOT NECESSARILY ALL SITE INSTRUCTIONS. R. RADLOFF & ASSOCIATES HAS COMPOSED THIS RECORD DRAWING AS REQUESTED BY THE CITY OF PRINCE GEORGE.

THE UNDERSIGNED DOES NOT WARRANT OR GUARANTEE, NOR ACCEPT ANY RESPONSIBILITY FOR THE ACCURACY OR COMPLETENESS OF THE AS-CONSTRUCTED INFORMATION SUPPLIED BY OTHERS CONTAINED IN THESE DRAWINGS, BUT DOES, BY SEALING AND SIGNING, CERTIFY THAT THE AS-CONSTRUCTED INFORMATION, IF ACCURATE AND COMPLETE, PROVIDES AN AS-CONSTRUCTED SYSTEM WHICH SUBSTANTIALLY COMPLIES IN ALL RESPECTS WITH THE ORIGINAL DESIGN INTENT.

LOCATION OF UNDERGROUND SERVICES HAS BEEN DETERMINED FROM RECORDS DRAWINGS PREPARED BY OTHERS. R. RADLOFF & ASSOCIATES ASSUMES NO RESPONSIBILITY FOR THE ACCURACY OF THE RECORD DRAWINGS. THE CONTRACTOR IS RESPONSIBLE FOR CONFIRMING LOCATION PRIOR TO COMMENCING CONSTRUCTION.



LEGEND		
EXISTING		
EXISTING EDGE OF PAVEMENT / GUTTER LINE		
PROPERTY LINES		
SANITARY MAIN		
STORM MAIN		
SANITARY SERVICE		
WATER SERVICE		
MANHOLE SANITARY W/FORM & C&D: 668.354		
CULVERT		
DITCH OR SWALE		
WATER MAIN & VALVE		
BLOWOFF HYDRANT		
FIRE HYDRANT		
FENCE		
PROPOSED		
CONTOUR ELEVATION: 667.50		
RIGHT-OF-WAY / EASEMENT		
PROPERTY LINE		
EDGE OF PAVEMENT / GUTTER LINE		
EDGE OF UTILITY ELEVATION: 668.354		
PROPERTY LINE		
STORM MAIN		
MANHOLE SANITARY W/FORM & C&D: 668.354		
CULVERT		
DITCH OR SWALE		
WATER MAIN & VALVE		
FIRE HYDRANT		
ROAD SIGN		
UTILITY LIGHTING		
POWER LINE		
TELEPHONE LINE		

No.	DATE	REVISION	DR.
6	23/05/26	ISSUED FOR RECORD	DJF
5	22/06/13	ISSUED FOR CONSTRUCTION	DJF
4	22/03/03	ISSUED FOR APPROVAL	SDF
3	21/10/04	ISSUED FOR CONSTRUCTION	DJF
2	21/07/19	FOR BUILDING PERMIT	EJG
1	21/04/06	FOR DEVELOPMENT PERMIT	DJF



DRAWN:	DJF
CHECKED:	DJF
ENGINEER:	DSF
SURVEY FILE:	
DRAWING FILE:	905-001-03.dwg
CORRESPONDENCE:	CPG
GRID:	
DATE:	MAY 2023
SCALE:	
HORIZ:	1:100
VERT:	

PRINCE GEORGE DOMINO'S
SITE DEVELOPMENT
GRADING PLAN

CONSULTANT'S PROJECT No.
905-001-03
DRAWING No.
C005



R. Radloff & Associates Inc.
Engineering, Planning & Consulting
1820 3rd Avenue
Prince George, B.C. V2M 1G4
Ph: (250) 562-6861
Fax: (250) 562-6826

SHEET No.	REV. No.
5 of 12	6