



This information has been provided
subject to the *Federal Copyright Act*
and in accordance with the Provincial
Freedom of Information and Protection
of Privacy Act.


The City of Prince George does not represent or guarantee that the information contained in this document is accurate or reliable, and any person who relies on this information in this document does so at their own risk.

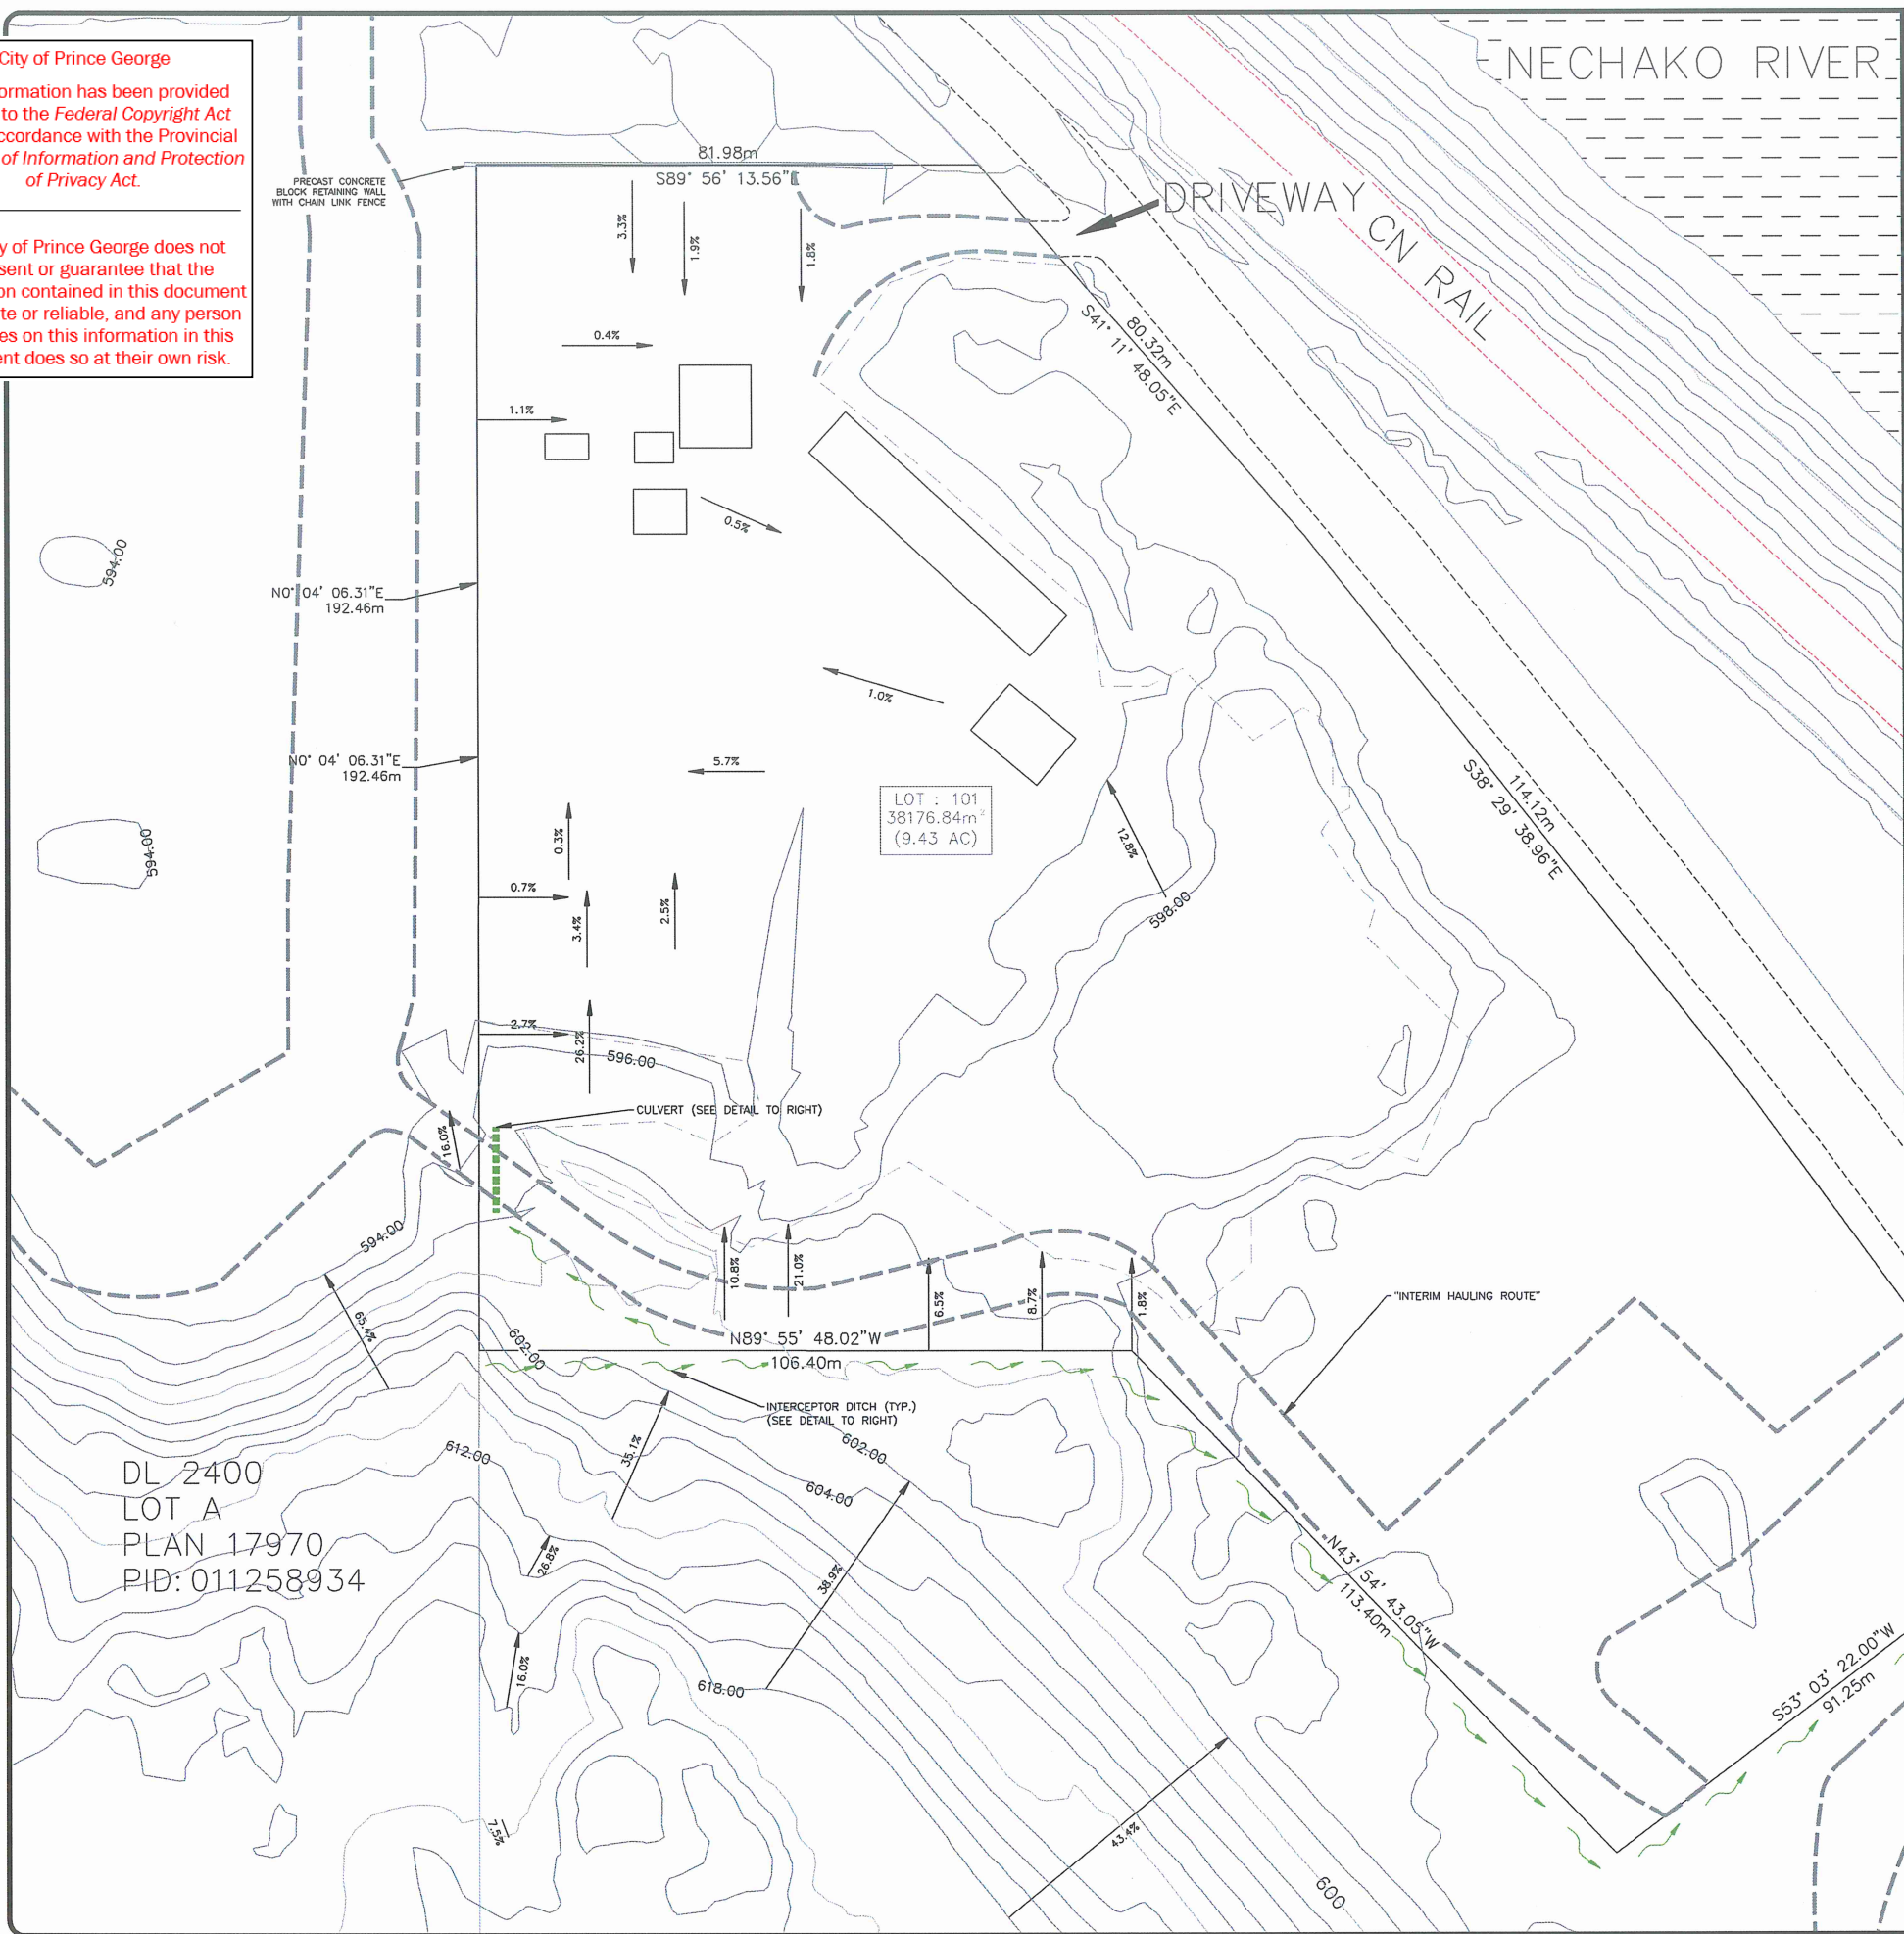


DRAINAGE DITCH TO BE INSTALLED

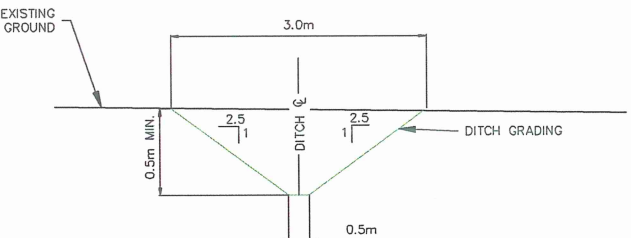

CULVERT TO BE INSTALLED

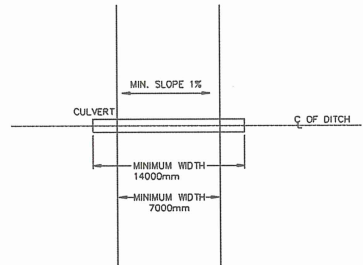

TYPICAL DRIVEWAY CULVERT

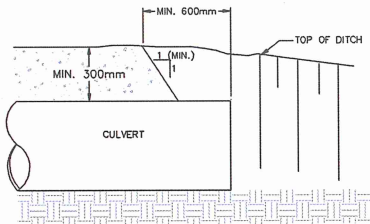


NOTE: 1. MINIMUM PIPE DIAMETER IS 400mm.

DRIVEWAYS

OTWAY ROAD

 NOTE:
1. THE ASSOCIATED DRAINAGE FLOW ENTERING THE ADJACENT PROPERTY WERE CALCULATED BASED ON THE 1:10 YEAR 24 HOUR STORM EVENT.

**Radloff**

R. Radloff & Associates Inc.
Engineering, Planning & Consulting
1820 3rd Avenue
Prince George, B.C. V2M 1G4
Ph: (250) 562-6861
Fax: (250) 562-6826

LEGEND

EXISTING

EXISTING EDGE OF PAVEMENT / CUTTER LINE

PROPERTY LINE

SANITARY MAIN

STORM MAIN

MANHOLE SANITARY/STORM & CATCHBASIN

CULVERT

DITCH OR SWALE

WATER MAIN & VALVE

BLOWOFF HYDRANT

FIRE HYDRANT

EXISTING EDGE OF GRAVEL ROAD

EXTENTS OF GRAVEL YARD

CONTOUR ELEVATION 667.50

RIGHT-OF-WAY / EASEMENT

PROPERTY LINE

EDGE OF PAVEMENT / CUTTER LINE

DESIGN CUTTER ELEVATION 668.354

SANITARY MAIN

STORM MAIN

MANHOLE SANITARY/STORM & CATCHBASIN

CULVERT

DITCH OR SWALE

WATER MAIN & VALVE

FIRE HYDRANT

ROAD SIGN

RO	17/10/16	REVIEW	MM
No.	DATE	REVISION	DR.



CITY OF
PRINCE GEORGE
Development Services

DRAWN:	BRL
CHECKED:	SAR/DF
ENGINEER:	RPR
SURVEY FILE:	
DRAWING FILE:	
CORRESPONDENCE:	CPG
GRID:	
DATE:	2017/08/25
SCALES HORZ. 1:750 VERT.	

ROLLING MIX SUBDIVISION

DRAINAGE PLAN

CONSULTANTS PROJECT No.

878-001-10

DRAWING No.

C001

SHEET No.

1 of 1

REV. No.

R0