

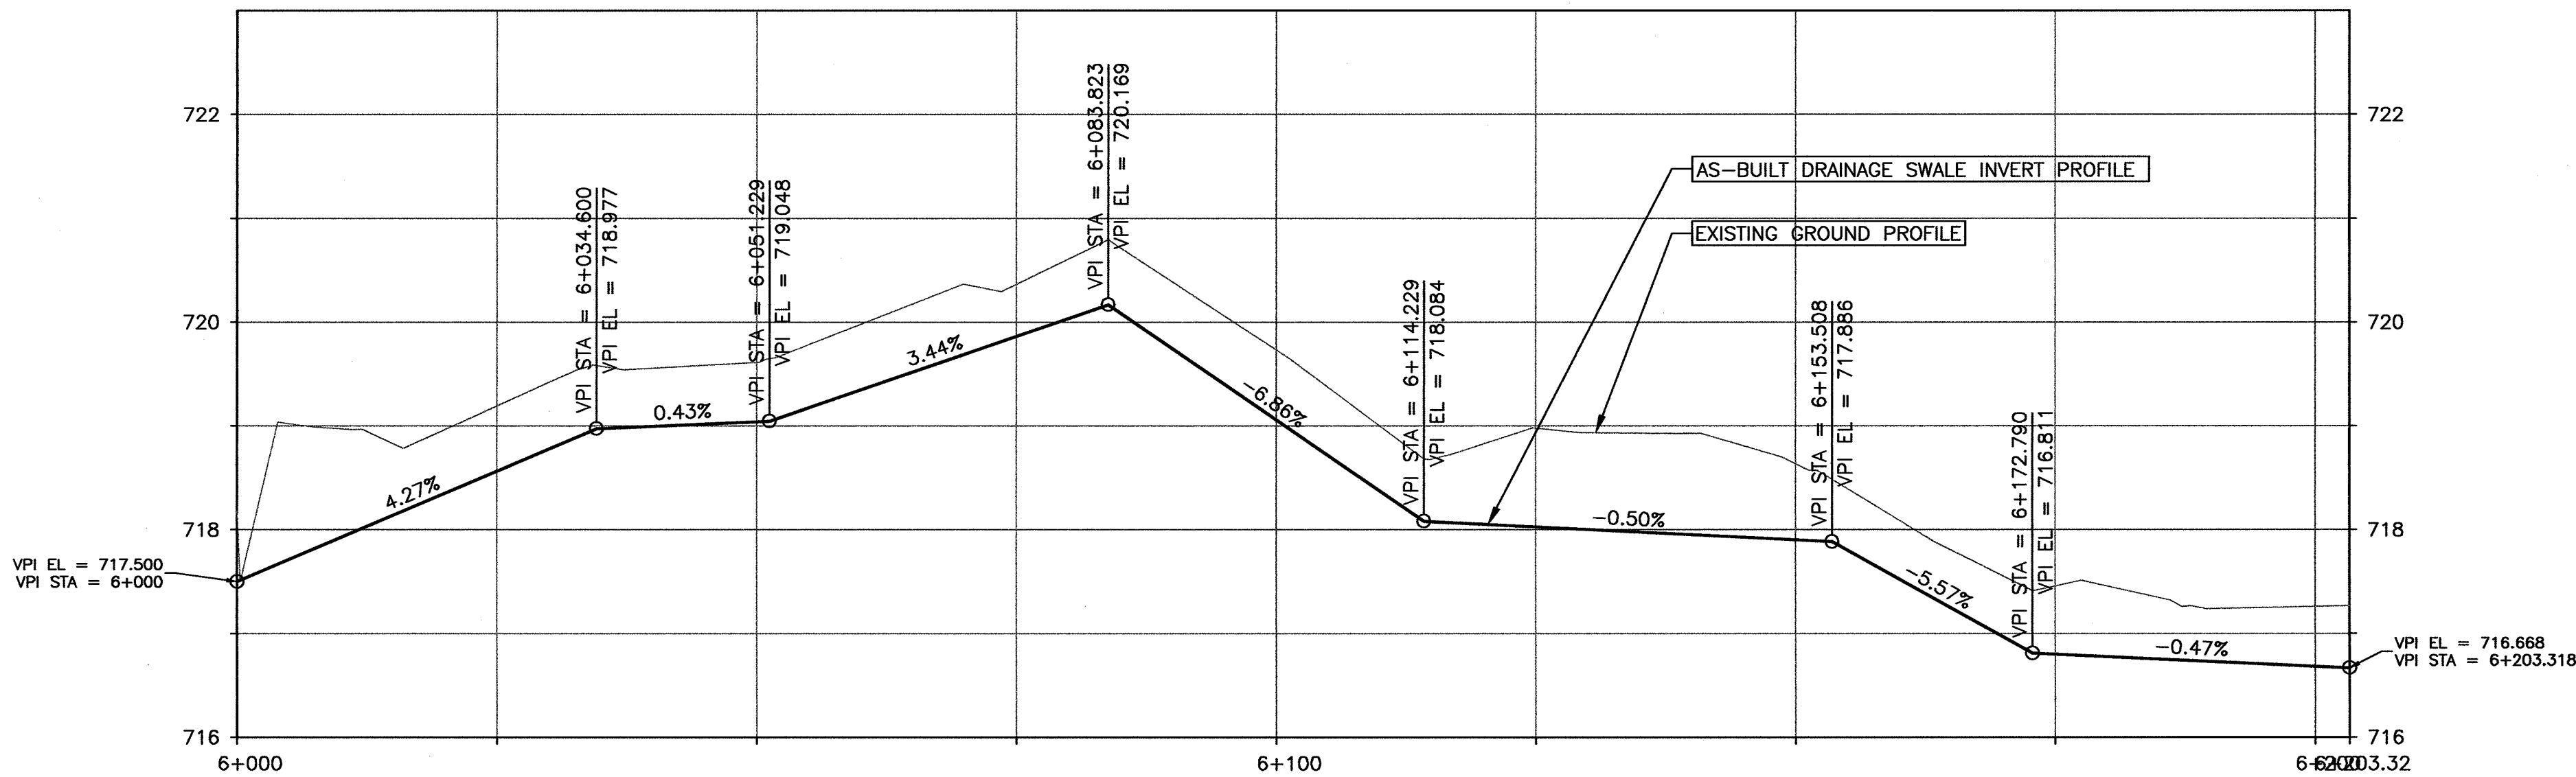


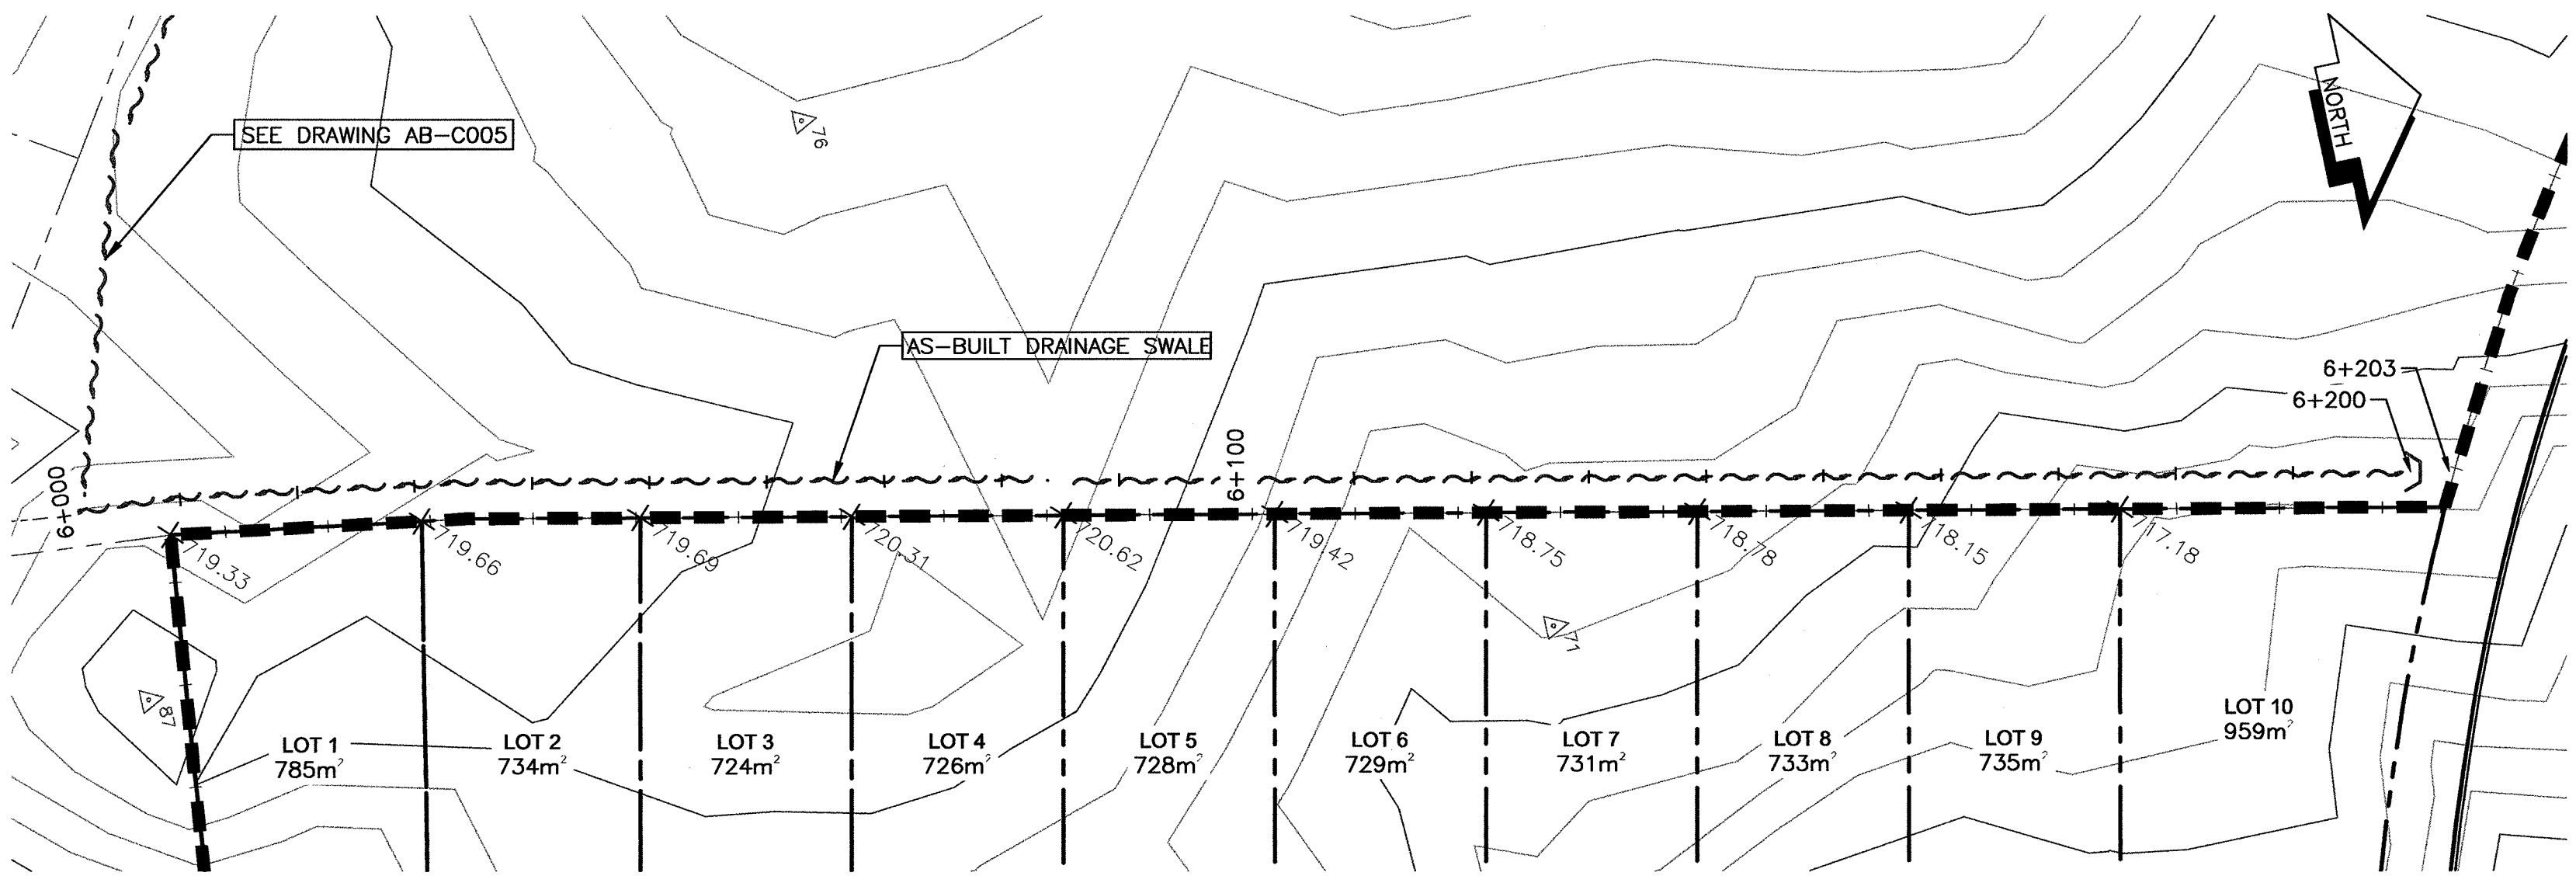

DRAINAGE SWALE PROFILE

NOTE: SEE DRAWING AB-C005 FOR DRAINAGE SWALE TYPICAL CROSS SECTION.

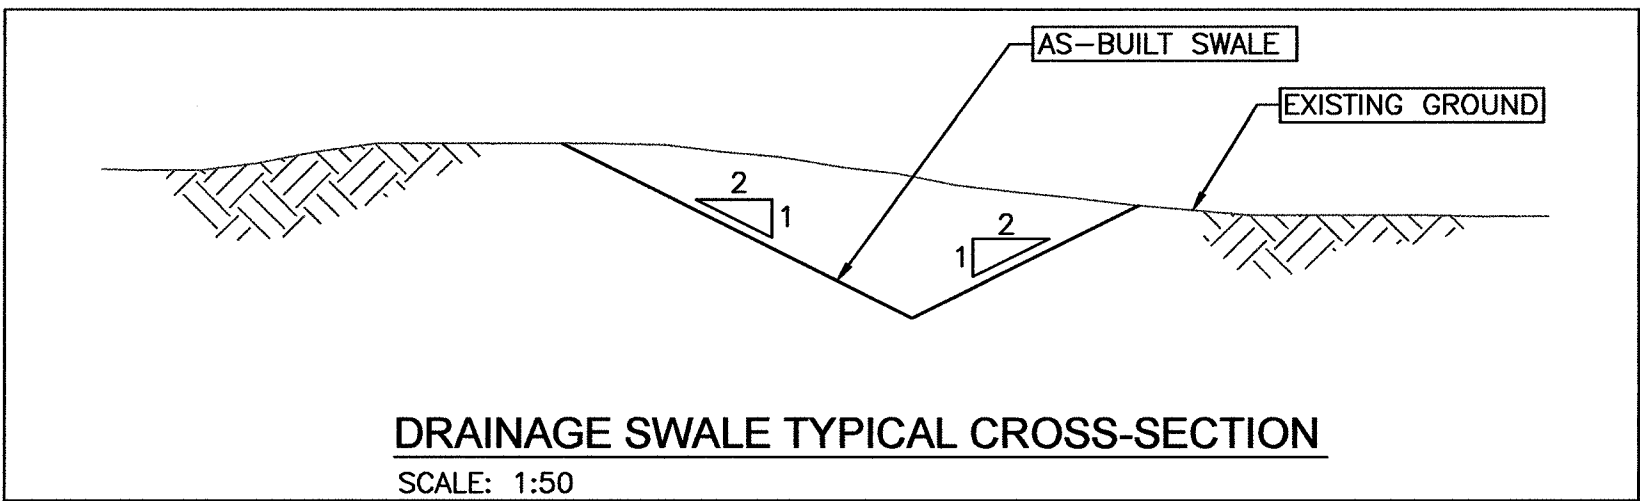

DRAINAGE SWALE TYPICAL CROSS-SECTION
SCALE: 1:50

LEGEND			
EXISTING			
	21	SURVEY HUB	
	SM	INTEGRATED SURVEY MONUMENT	
	16	GEOTECHNICAL TEST PIT LOCATION	
		EX. PROPERTY LINE & IRON PIN	
		EX. FENCE	
		EX. SANITARY MAIN & MANHOLE	
		EX. STORM MAIN & MANHOLE	
		EX. CULVERT	
	CBMH	EX. CB MANHOLE / CB	
	WV	EX. WATER MAIN & VALVE	
	FH	EX. FIRE HYDRANT	
	LS	EX. LAMP STANDARD	
	OP	EX. OVERHEAD POWER	
	PP	EX. POWER POLE & GUY WIRE	
	UG	EX. UNDERGROUND POWER	
	UGS	EX. UNDERGROUND NAT. GAS	
	SG	EX. SIGN	
		EX. TOP OF SLOPE	
		EX. DITCH LINE	
		EX. TOE OF SLOPE	
		EX. BUILDING	
AS-BUILT			
	AB LEGAL	AB LEGAL	
	AB EASEMENT	AB EASEMENT	
	AB SANITARY MAIN & MANHOLE	AB SANITARY MAIN & MANHOLE	
	AB SIGN	AB SIGN	
	AB STORM MAIN & MANHOLE	AB STORM MAIN & MANHOLE	
	AB C.S.P. CULVERT	AB C.S.P. CULVERT	
	AB CONCRETE HEADWALL	AB CONCRETE HEADWALL	
	AB CATCHBASIN & DCB	AB CATCHBASIN & DCB	
	AB DITCH	AB DITCH	
	AB WATER MAIN & VALVE	AB WATER MAIN & VALVE	
	AB FIRE HYDRANT	AB FIRE HYDRANT	
	AB CONCRETE SIDEWALK	AB CONCRETE SIDEWALK	
	AB ASPHALT	AB ASPHALT	
	AB CUT & FILL SLOPES	AB CUT & FILL SLOPES	
3	01/18/13	ISSUED FOR AS-BUILT	SDS
2	08/31/11	ISSUED FOR CONSTRUCTION DDA	DDA
1	07/04/11	ISSUED FOR APPROVAL	DDA
NO.	DATE	REVISION	DR.



DRAWN:	DDA
CHECKED:	JRB
ENGINEER:	JRB
SURVEY FILE:	
DRAWING FILE:	C3013-1273-14AS-BUILT
CORRESPONDENCE:	CPG
GRID:	
DATE:	11/02/2011
SCALES:	HORZ. 1:1000


INFINITY GROUP OF COMPANIES
UNIVERSITY HEIGHTS - PHASE 3
43 LOT SUBDIVISION
DRAINAGE SWALE
PLAN AND PROFILES




CONSULTANTS PROJECT No.	1273-14-02
DRAWING No.	AB-C006

SHEET No.	6 OF 8
REV. No.	3

AS-BUILT INFORMATION

L&M
ENGINEERING LIMITED
1210 FOURTH AVENUE
PRINCE GEORGE, B.C.
V2L 3J4
TEL. (250) 562-1977
FAX (250) 562-1967

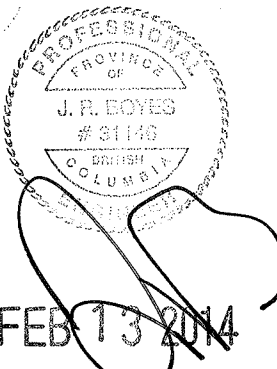

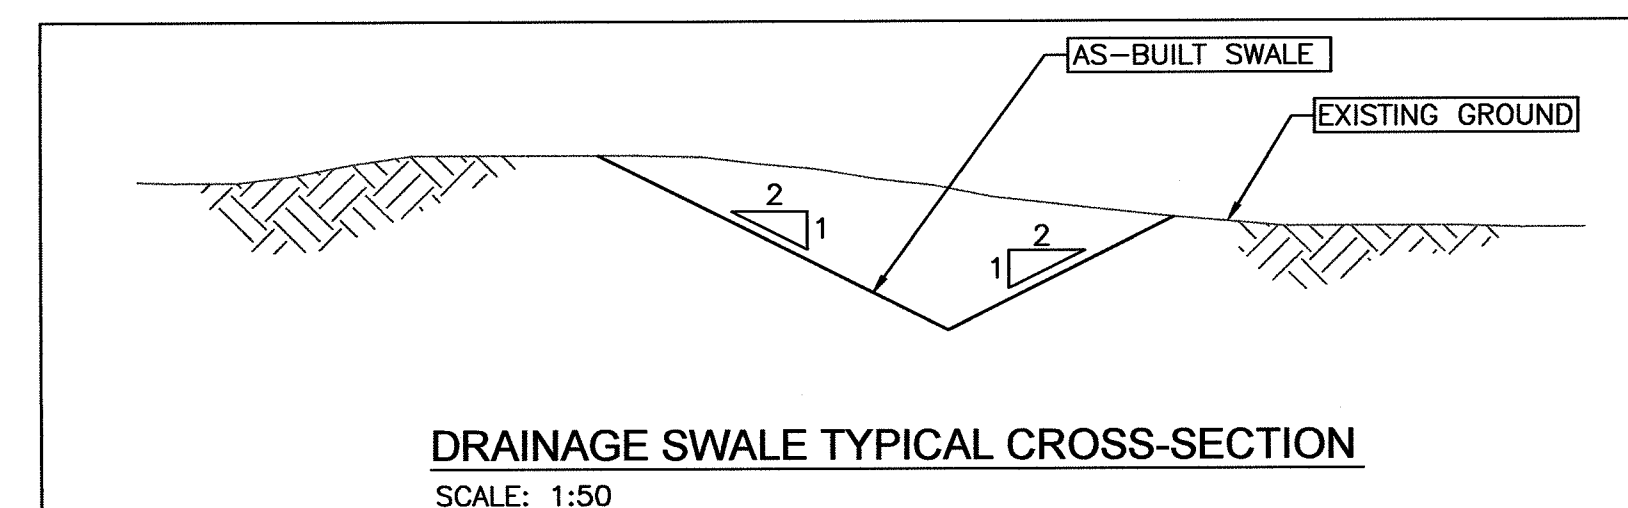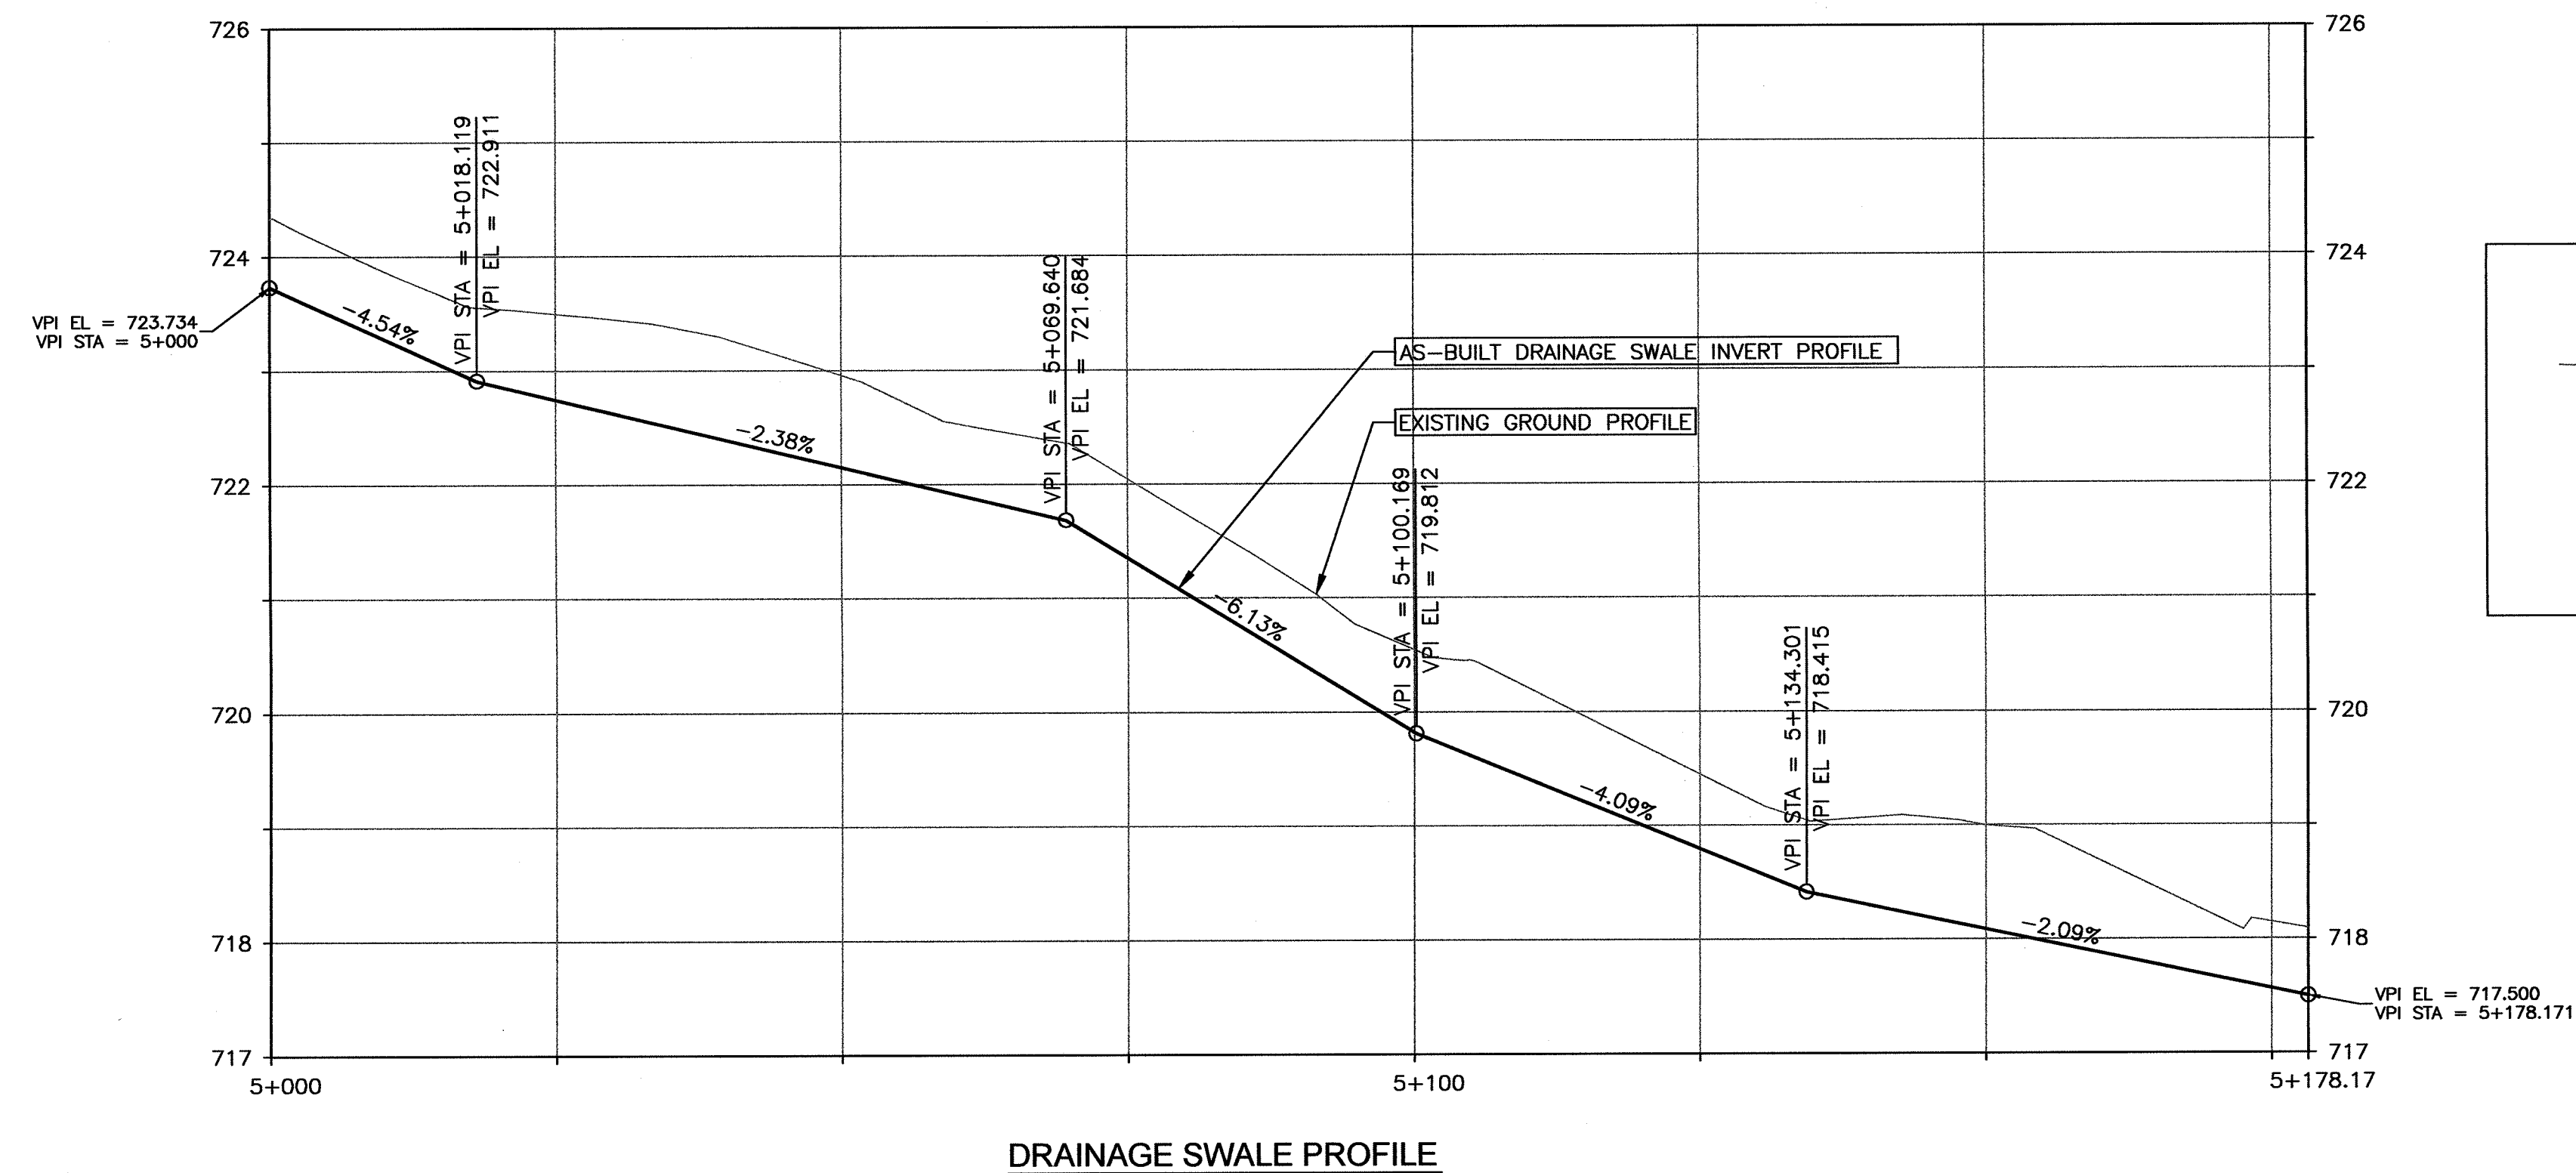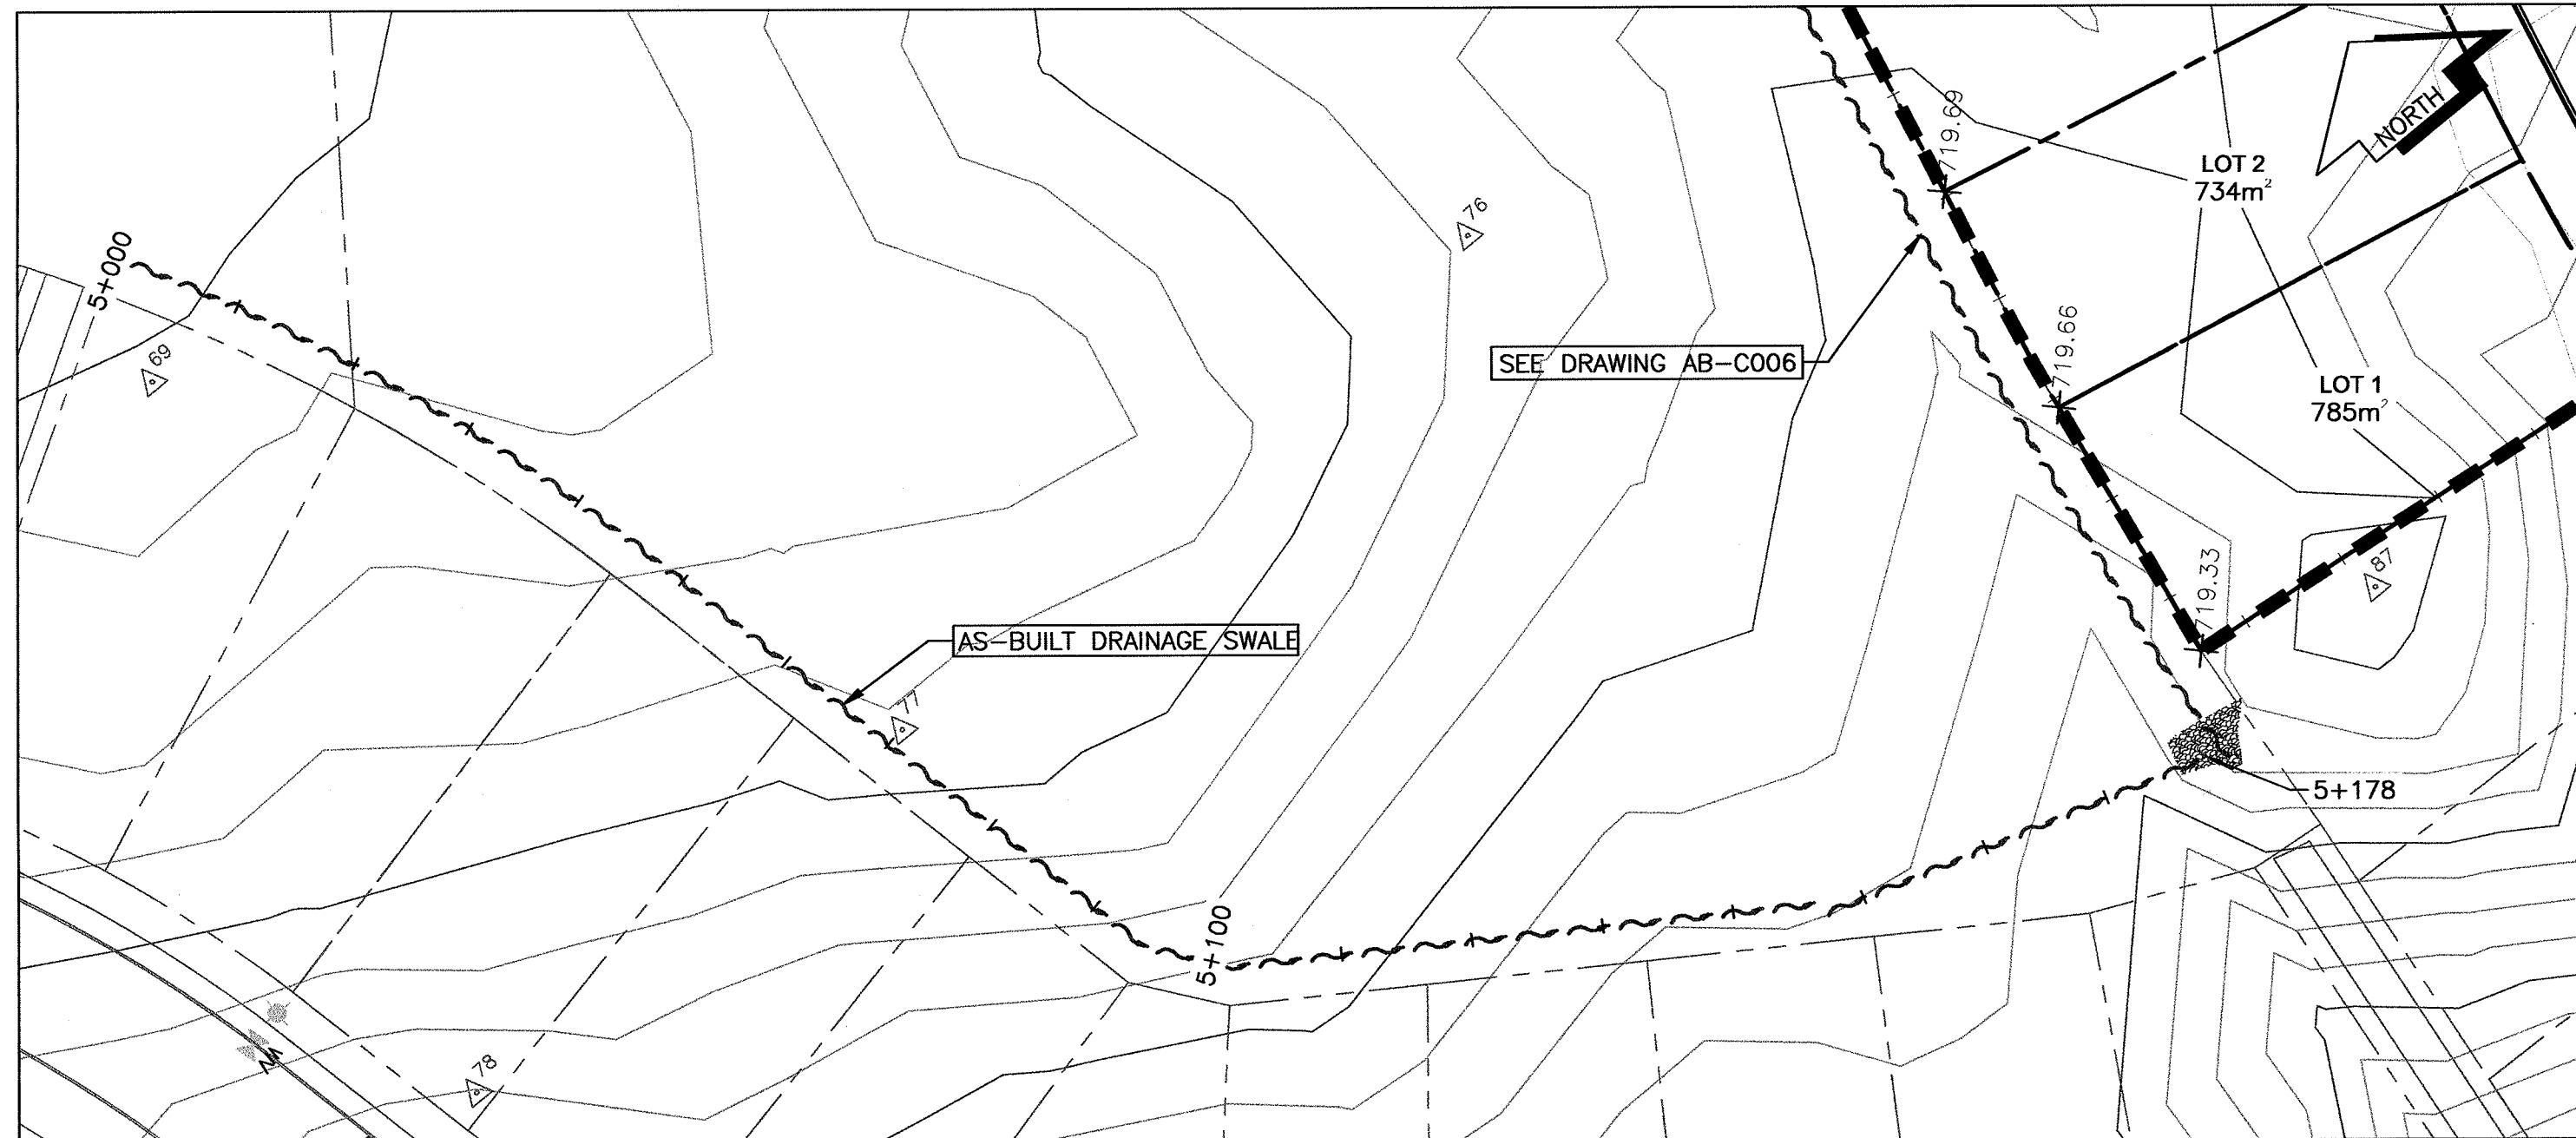

LEGEND

EXISTING			
	21	SURVEY HUB	
	ISM	INTEGRATED SURVEY MONUMENT	
	8	GEOTECHNICAL TEST PIT LOCATION	
		EX. PROPERTY LINE & IRON PIN	
		EX. FENCE	
		EX. SANITARY MAIN & MANHOLE	
		EX. STORM MAIN & MANHOLE	
		EX. CULVERT	
		EX. CB MANHOLE / CB	
		EX. WATER MAIN & VALVE	
		EX. FIRE HYDRANT	
		EX. LAMP STANDARD	
		EX. POWER POLE & GUY WIRE	
		EX. UNDERGROUND POWER	
		EX. UNDERGROUND NAT. GAS	
		EX. SIGN	
		EX. TOP OF SLOPE	
		EX. DITCH LINE	
		EX. TOE OF SLOPE	
		EX. BUILDING	
		EX. ASPHALT	
AS-BUILT			
		AB LEGAL	
		AB EASEMENT	
		AB SANITARY MAIN & MANHOLE	
		AB SIGN	
		AB STORM MAIN & MANHOLE	
		AB C.S.P. CULVERT	
		AB CONCRETE HEADWALL	
		AB CATCHBASIN & DCB	
		AB DITCH	
		AB WATER MAIN AND VALVE	
		AB FIRE HYDRANT	
		AB CONCRETE SIDEWALK	
		AB ASPHALT	
		AB CUT & FILL SLOPES	
3	01/18/13	ISSUED FOR AS-BUILT	SDS
2	08/31/11	ISSUED FOR CONSTRUCTION	DDA
1	07/04/11	ISSUED FOR APPROVAL	DDA
NO.	DATE	REVISION	DR.



CITY OF
PRINCE GEORGE
Development Services

DRAWN:	DDA
CHECKED:	JRB
ENGINEER:	JRB
SURVEY FILE:	
DRAWING FILE:	C3D13-1273-14AS-BUILT
CORRESPONDENCE:	CPG
GRID:	
DATE:	11/02/2011
SCALES:	HORZ. 1:1000

INFINITY GROUP OF COMPANIES
UNIVERSITY HEIGHTS - PHASE 3
43 LOT SUBDIVISION
DRAINAGE SWALE
PLAN AND PROFILES

CONSULTANTS PROJECT No.
1273-14-02
DRAWING No.
AB-C005

SHEET No.	REV. No.
5 OF 8	3

AS-BUILT INFORMATION

L&M
ENGINEERING LIMITED

1210 FOURTH AVENUE
PRINCE GEORGE, B.C.
V2L 3J4
TEL (250) 562-1977
FAX (250) 562-1967

