

City of Prince George HISTORY SHEET

620

SHEET NUMBER

5406

Roll Number

Legal:

LOT'S

13 & 14

BLOCK

239

D.L.

343

PLAN

1268

Address:

1566 QUEENSWAY

Sanitary Connection: #

1563

SIZE

MATERIAL

INV.

1893.80

CONNECTED

Water Connection #

381

SIZE

3/4"

MATERIAL

2u

METER

CONNECTED

Storm Connection: #

SIZE

MATERIAL

INV.

CONNECTED

Cash Receipt No's:

WATER

SANITARY

STORM

CURB FROM PROPERTY LINE

PAVEMENT WIDTH

B.C. HYDRO

O.H.

UNDERGROUND CONNECTION

B.C. TELEPHONE

U.G.

UNDERGROUND CONNECTION


INLAND GAS

AS SHOWN

Information Sheets:

Comments:

SITE PLAN N.T.S.

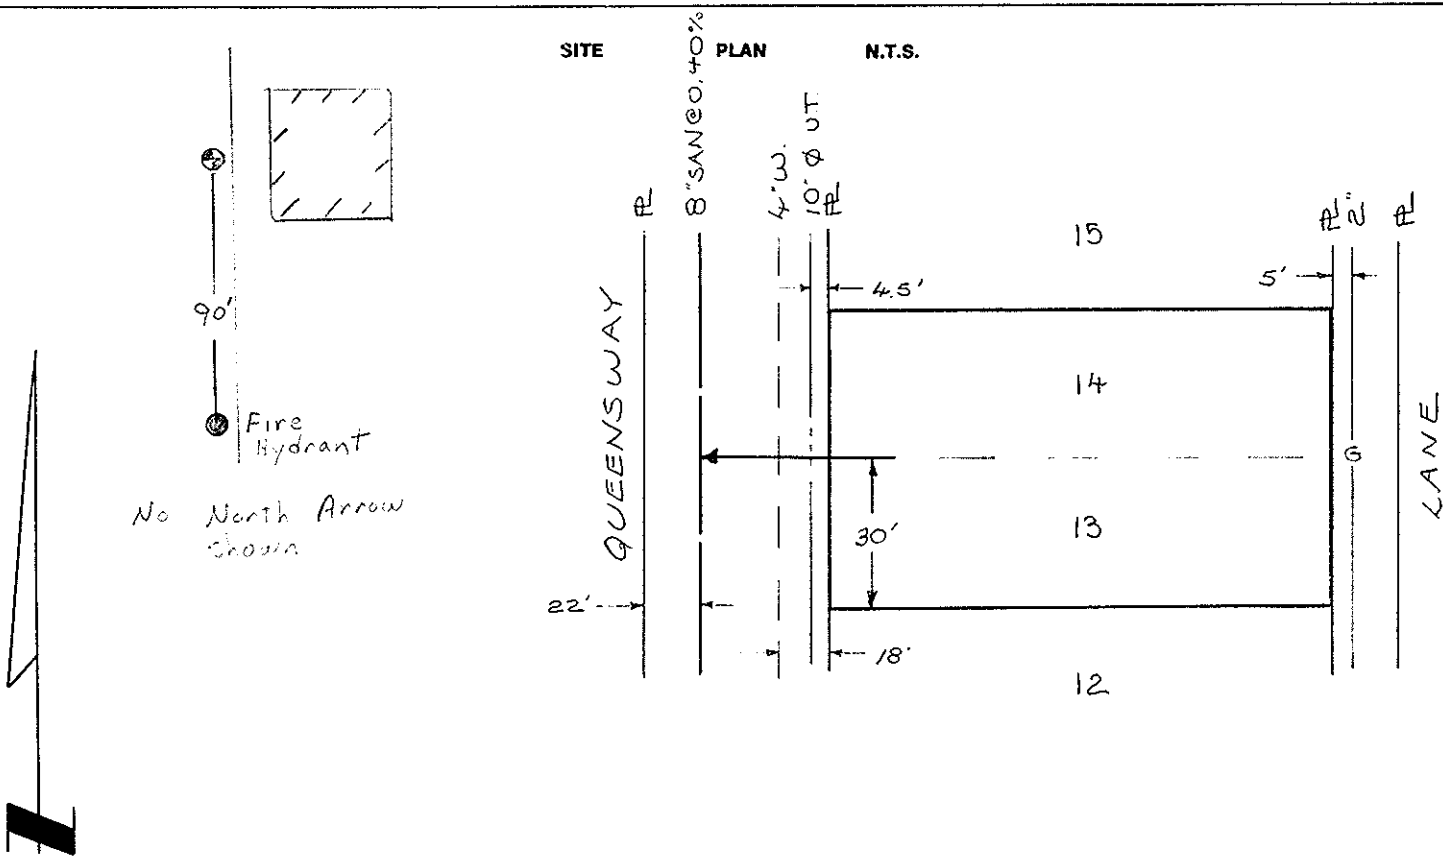

No North Arrow shown

