

City of Prince George HISTORY SHEET

SHEET NUMBER

Roll Number 004678265

Legal: LOT'S 3 BLOCK _____ D.L. 754 PLAN 2-1920

Address: 8129 ST. LAWRENCE AVE

Sanitary Connection: # _____ SIZE 100 M.M. MATERIAL P.V.C. INV. 636.772 M. CONNECTED

Water Connection # _____ SIZE 20 M.M. MATERIAL CU. METER _____ CONNECTED

Storm Connection: # _____ SIZE 100 M.M. MATERIAL P.V.C. INV. 636.772 M. CONNECTED

Cash Receipt No's: WATER _____ SANITARY _____ STORM _____

CURB FROM PROPERTY LINE 3.658 M. PAVEMENT WIDTH 12.80 M.

B.C. HYDRO 0.914 M. UG UNDERGROUND CONNECTION

B.C. TELEPHONE 0.914 M. UG UNDERGROUND CONNECTION

INLAND GAS 3.00 M.

Information Sheets:

Comments: 66' R/W. BENCH MARK # ELEVATION = 638.971 M.

HYDRANT ARROW S.W. CORNER ST. LAWRENCE AND ST. PATRICK

ALL MEASUREMENTS IN METRIC

SITE PLAN N.T.S.

450 M.M. DIA. SANITARY @ 1.31%

1066 M.M. DIA. STORM @ 1.36%


250 M.M. DIA. WATER

ST. LAWRENCE AVE.

CURB

GAS

HYDRO

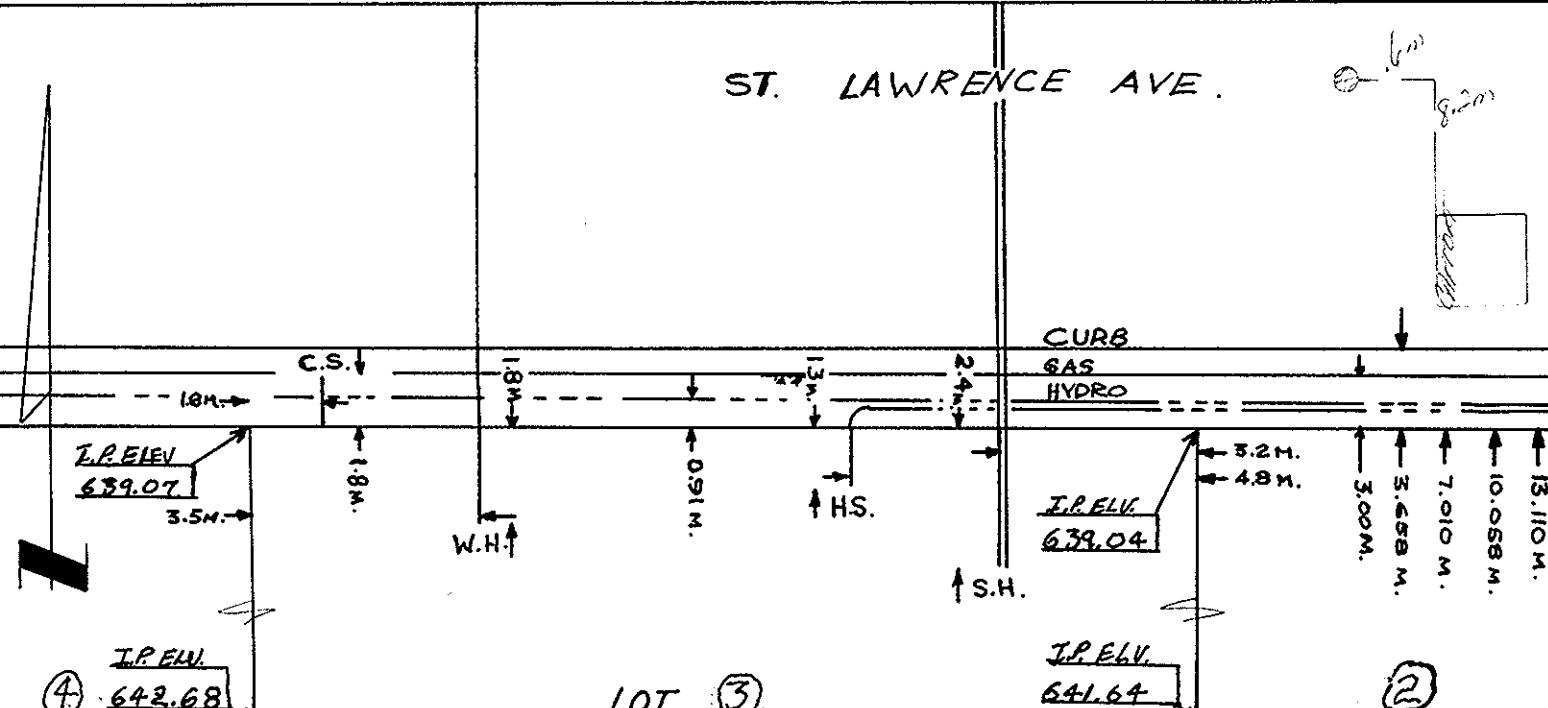

④ I.P. ELEV. 642.68

LOT ③

I.P. ELEV. 641.64

②