

City of Prince George

HISTORY SHEET

004719743

SHEET NUMBER **Nº 4269** Roll Number **808**

Legal: LOT'S **8-9** BLOCK **8** D.L. **1429** PLAN **676**

Address: **829 DOUGLAS STREET**

Sanitary Connection: # **1753** SIZE **100 mm** MATERIAL INV. CONNECTED

Water Connection # **1376** SIZE **13 mm** MATERIAL METER CONNECTED

Storm Connection: # SIZE MATERIAL INV. CONNECTED

Cash Receipt No's: WATER SANITARY STORM

CURB FROM PROPERTY LINE **4.877** PAVEMENT WIDTH **10.363**

B.C. HYDRO UNDERGROUND CONNECTION


B.C. TELEPHONE UNDERGROUND CONNECTION

INLAND GAS **IN LANE AS SHOWN**

Information Sheets:

Comments:

SITE PLAN N.T.S.

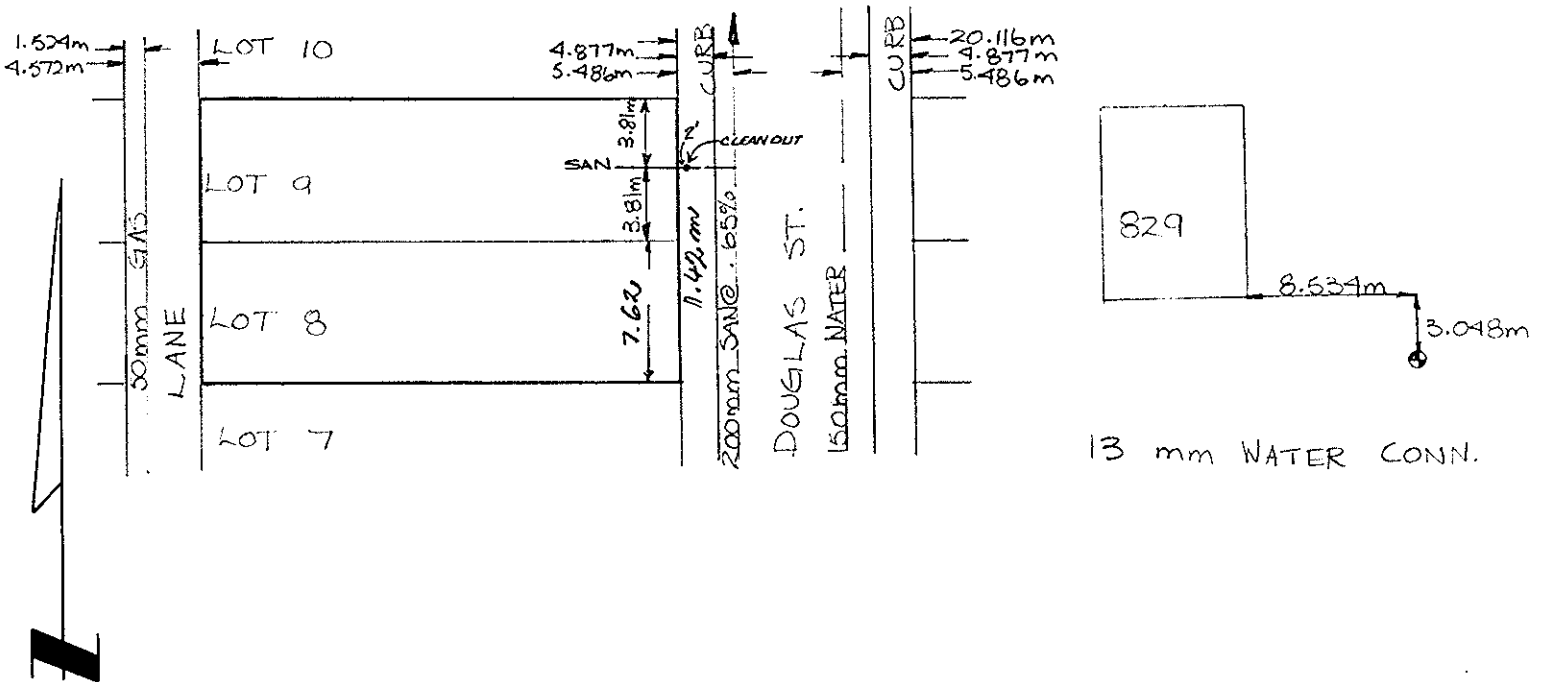

13 mm WATER CONN.