

**City of Prince George
HISTORY SHEET**

004771486

SHEET NUMBER

Roll Number

529

Legal: LOT'S 1-2-1-1 BLOCK 17 D.L. 1429 PLAN 646 / 10594

Address: 1285 EWERT ST.

Sanitary Connection: # 94 SIZE MATERIAL INV. CONNECTED

Water Connection # 1450 SIZE 20 mm MATERIAL COP. METER CONNECTED

Storm Connection: # SIZE MATERIAL INV. CONNECTED

Cash Receipt No's: WATER SANITARY STORM

CURB FROM PROPERTY LINE PAVEMENT WIDTH


B.C. HYDRO UNDERGROUND CONNECTION

B.C. TELEPHONE UNDERGROUND CONNECTION

INLAND GAS

Information Sheets The information contained herein is for internal use only. Not to be relied upon unless confirmed by site inspection and/or investigation.

SITE PLAN N.T.S.

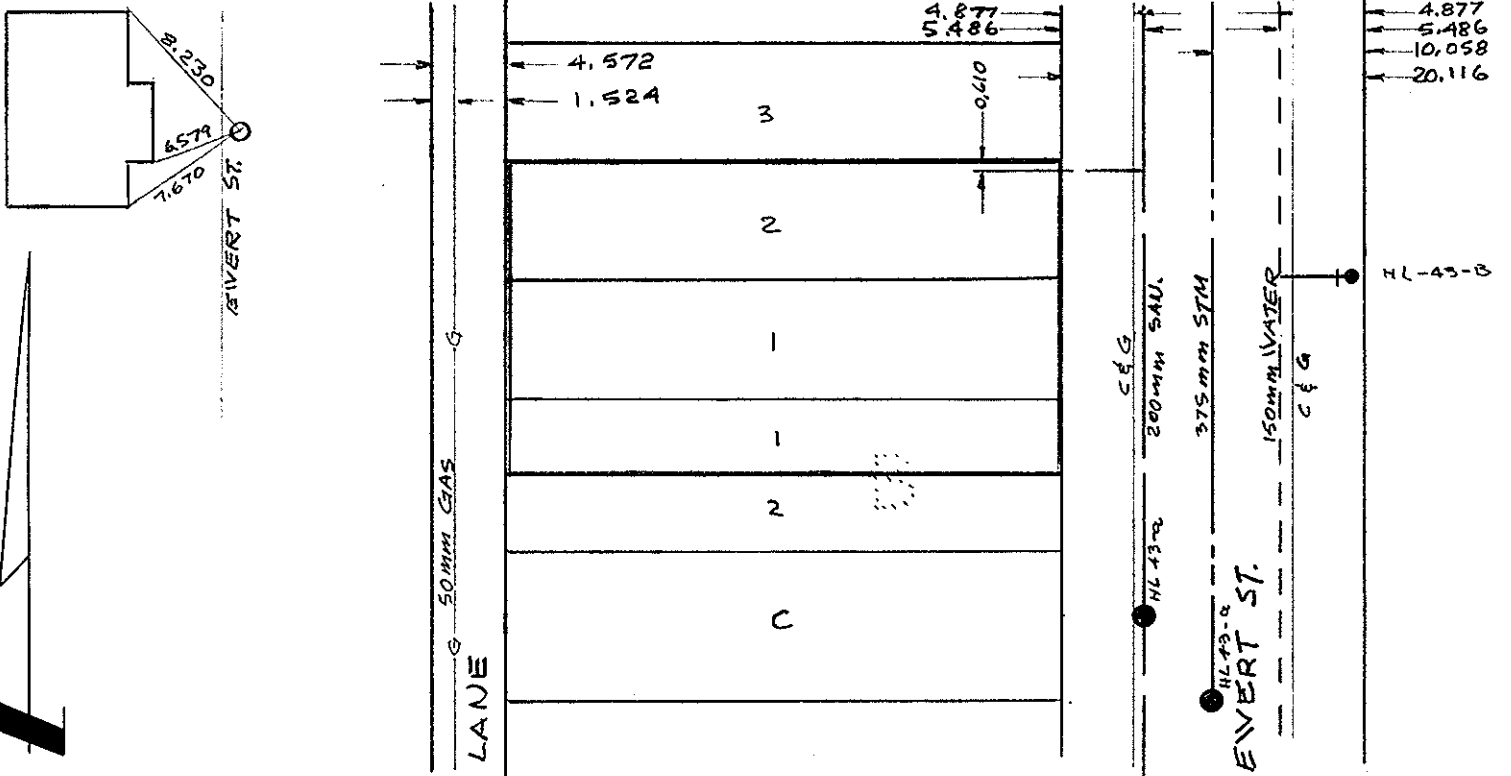

REPORT TO RECORDS

SEWER SERVICE INFORMATION

Lot No. _____ Block _____ D.L. _____

Address 1285 EWERT ST

Size of Connection 100mm 150mm 200mm Other _____

Type of Connection Transite PVC Other _____

Type of Cap Transite Cast Iron

LOCATION SKETCH



Descriptions:

Installed on the north-east property-line



Field Location By W Bond Date April 23, 2001

Checked by Foreman - Sewer Division _____