

City of Prince George HISTORY SHEET

SHEET NUMBER **11655** Roll Number **004954114**

Legal: LOT'S **B** BLOCK **D.L. 7634 & 4221** PLAN **16829**

Address: **4374 STEVENS DR.**

Sanitary Connection: # **SIZE 100 mm MATERIAL P.V.C. INV. CONNECTED**

Water Connection # **SIZE 20 mm MATERIAL CU. METER CONNECTED**

Storm Connection: # **SIZE MATERIAL INV. CONNECTED**

Cash Receipt No's: WATER SANITARY STORM

CURB FROM PROPERTY LINE PAVEMENT WIDTH **10.00 m**

B.C. HYDRO **O/H** UNDERGROUND CONNECTION


B.C. TELEPHONE **O/H** UNDERGROUND CONNECTION

INLAND GAS **AS SHOWN**

Information Sheets:

Comments: **THE INFORMATION CONTAINED HEREIN IS FOR INTERNAL USE ONLY. NOT TO BE RELIED UPON UNLESS CONFIRMED BY SITE INSPECTION AND/OR INVESTIGATION.**
SAN. ELEV. 1.3m BELOW GROUND @ R.

SITE PLAN N.T.S.

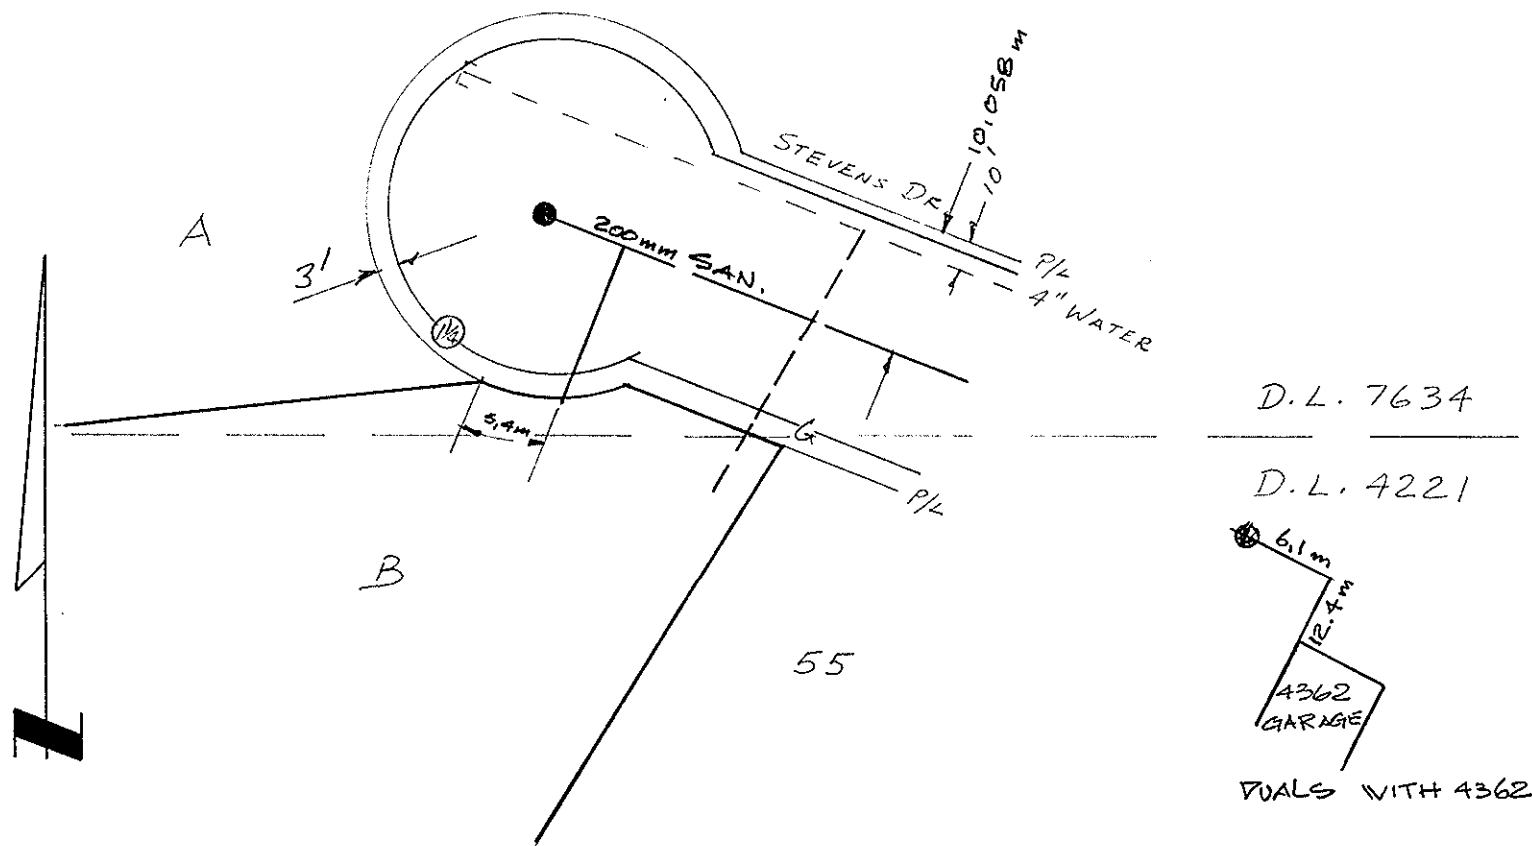

D.L. 7634

D.L. 4221

