

# City of Prince George HISTORY SHEET

SHEET NUMBER

Roll Number *006081 797*

Legal: LOT'S *C* BLOCK D.L. *4377* PLAN *28186*

Address: *2518* NORTHWOOD PULPMILL RD

Sanitary Connection: # SIZE MATERIAL INV. CONNECTED

Water Connection # *N/D.* SIZE MATERIAL METER CONNECTED

Storm Connection: # SIZE MATERIAL INV. CONNECTED

Cash Receipt No's: WATER SANITARY STORM

CURB FROM PROPERTY LINE PAVEMENT WIDTH

B.C. HYDRO UNDERGROUND CONNECTION


B.C. TELEPHONE UNDERGROUND CONNECTION

INLAND GAS

Information Sheets:

Comments:

SITE PLAN N.T.S.

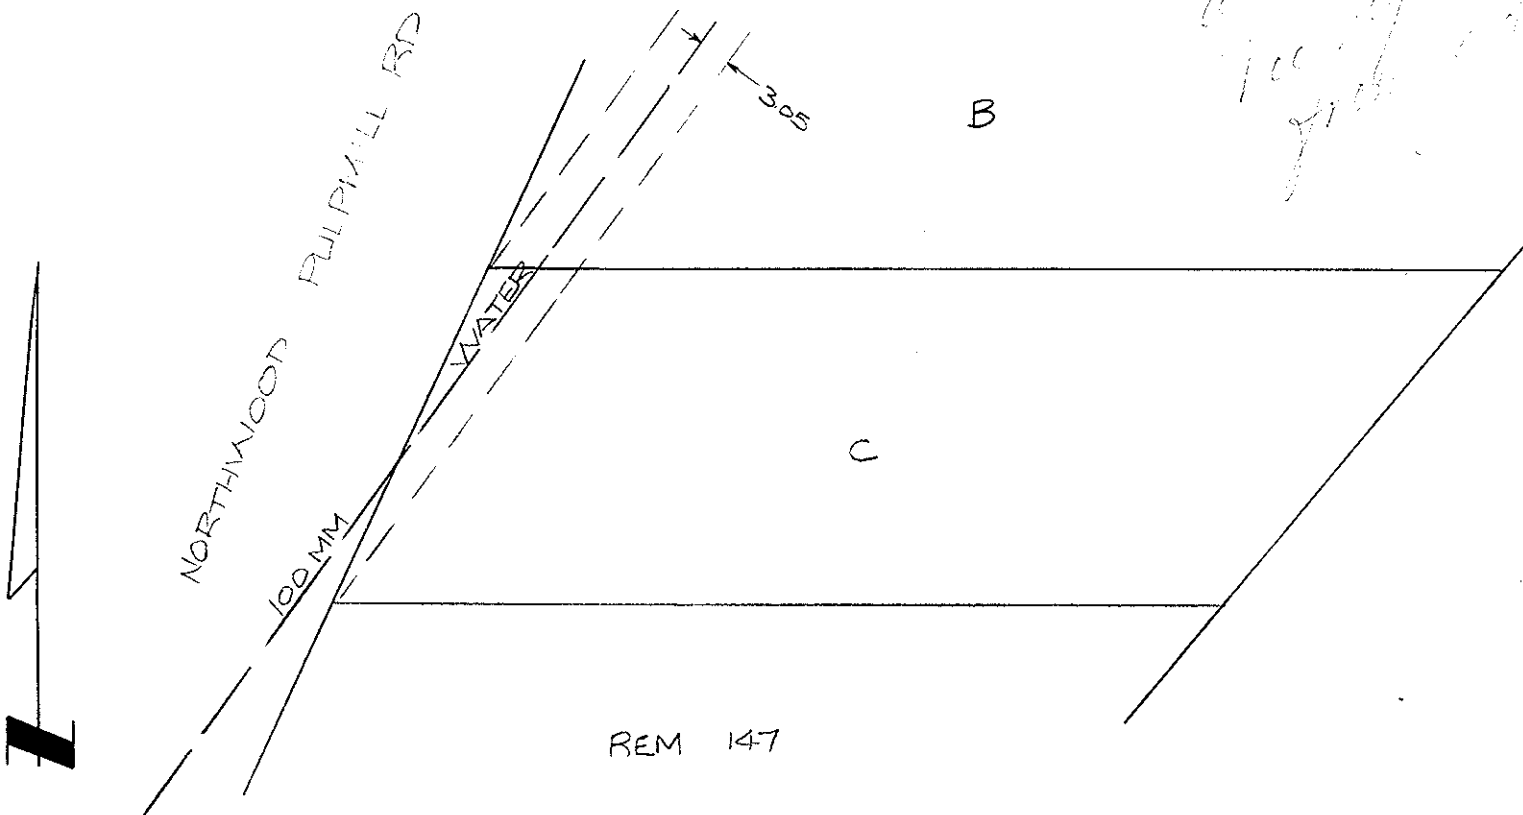

# REPORT TO RECORDS

## WATER SERVICE INFORMATION

Lot No. \_\_\_\_\_ Block \_\_\_\_\_ D.L. \_\_\_\_\_


Address 2518 NORTHWOOD PULPMILL RD.

Size of Connection  1/2"  3/4"  Other \_\_\_\_\_

Type of Connection  Copper  Iron

Thaw Wire  Yes  No

### LOCATION SKETCH

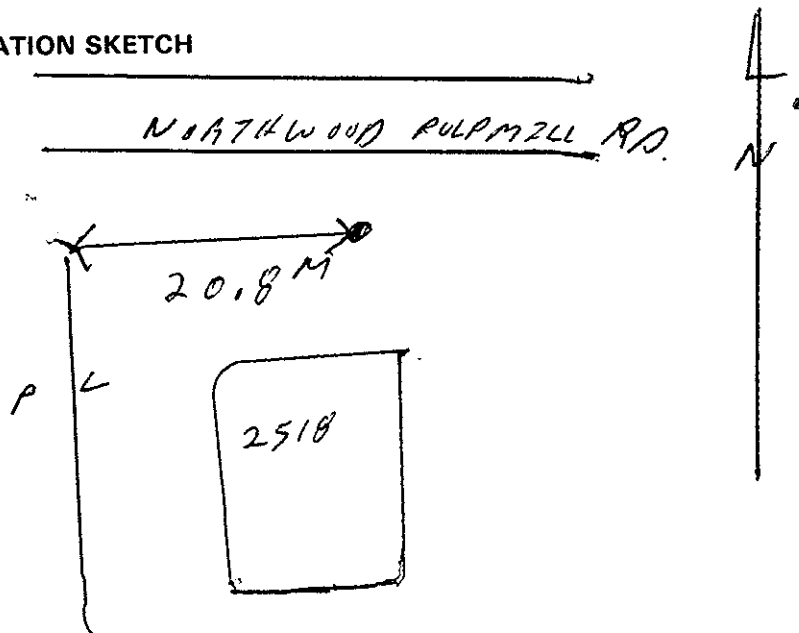

Field Location By A. ST. CROIX Date OCT-31-02

Checked by: \_\_\_\_\_