

**City of Prince George  
HISTORY SHEET**

006409768

SHEET NUMBER **No 1096** Roll Number **776**

Legal: LOT'S **17-18** BLOCK **37** D.L. **1429** PLAN **646**

Address: **938 IRWIN ST.**

Sanitary Connection: # **4621** SIZE **100mm** MATERIAL **A.C.S.** INV. **CONNECTED**

Water Connection # **1595** SIZE **13mm** MATERIAL **METER** **CONNECTED**

Storm Connection: #  SIZE  MATERIAL  INV. **CONNECTED**

Cash Receipt No's: WATER  SANITARY **2724** STORM

CURB FROM PROPERTY LINE  PAVEMENT WIDTH

B.C. HYDRO  UNDERGROUND CONNECTION


B.C. TELEPHONE  UNDERGROUND CONNECTION

INLAND GAS

Information Sheets:

Comments:

SITE PLAN N.T.S.

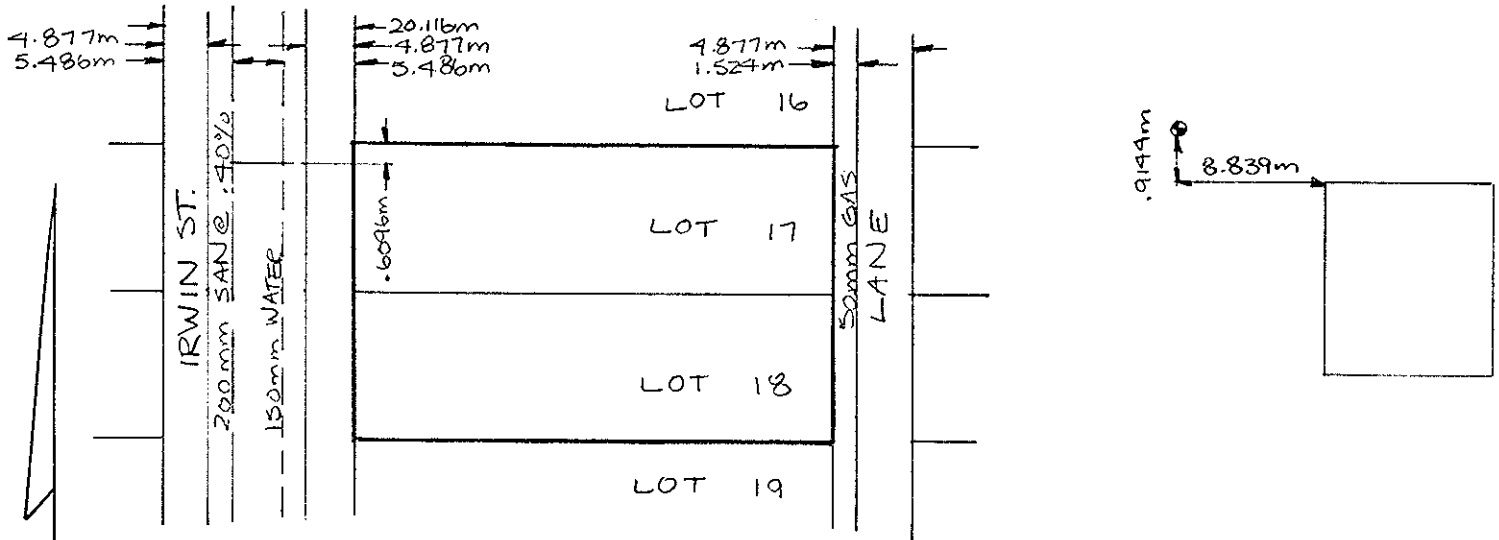

# REPORT TO RECORDS

## WATER SERVICE INFORMATION

Lot No. \_\_\_\_\_ Block \_\_\_\_\_ D.L. \_\_\_\_\_


Address 938 Irwin

Size of Connection  1/2"  3/4"  Other \_\_\_\_\_

Type of Connection  Copper  Iron

Thaw Wire  Yes  No

### LOCATION SKETCH

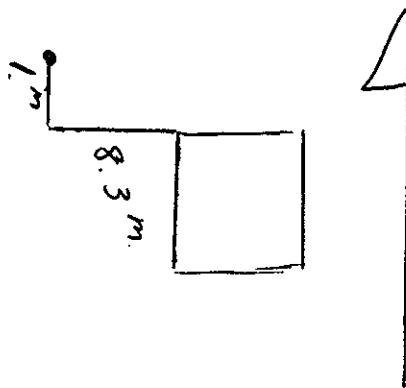

Field Location By \_\_\_\_\_ Date 6/8/92

Checked by: \_\_\_\_\_