


City of Prince George HISTORY SHEET

397

| | | |
|-------------------------|---------------------------------------|------------------------|
| SHEET NUMBER | N ^o 1241 | Roll Number |
| Legal: | LOT'S 13-14 BLOCK 5 D.L. 937 PLAN 752 | |
| Address: | 728 HARPER STREET | |
| Sanitary Connection: # | 4805 SIZE 100mm MATERIAL ACS. INV. | CONNECTED |
| Water Connection # | 1752 SIZE 20mm MATERIAL CU METER | CONNECTED |
| Storm Connection: # | | CONNECTED |
| Cash Receipt No's: | WATER SANITARY 2759 STORM | |
| CURB FROM PROPERTY LINE | 4.817m | PAVEMENT WIDTH |
| B.C. HYDRO | OVERHEAD | UNDERGROUND CONNECTION |
| B.C. TELEPHONE | OVERHEAD | UNDERGROUND CONNECTION |
| INLAND GAS | | |
| Information Sheets: | | |
| Comments: | | |

SITE PLAN N.T.S.

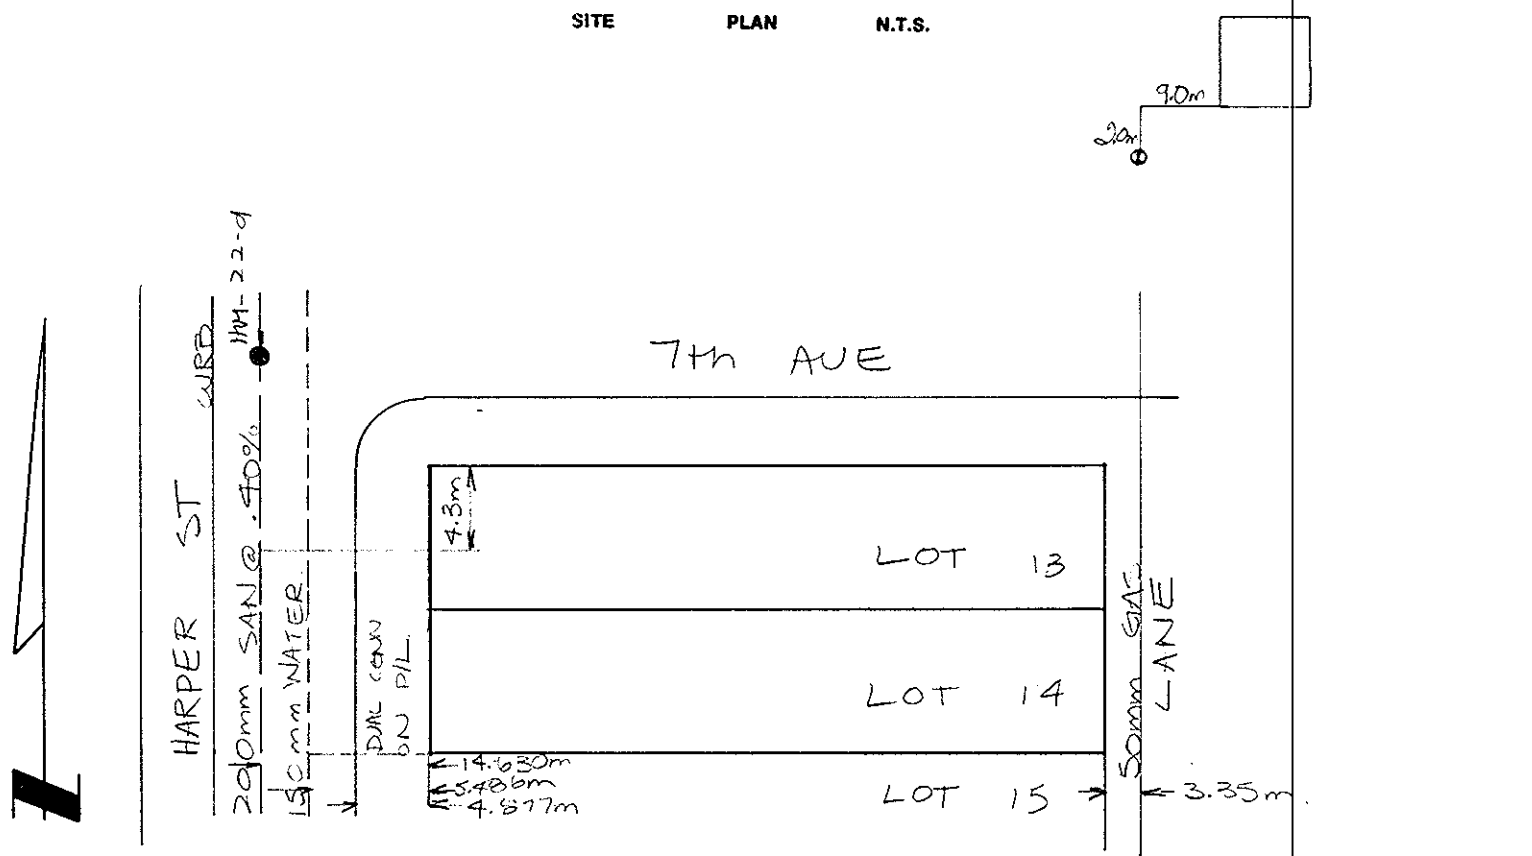

REPORT TO RECORDS

WATER SERVICE INFORMATION

Lot No. _____ Block _____ D.L. _____


Address 728. Harper

Size of Connection 1/2" 3/4" Other _____

Type of Connection Copper Iron

Thaw Wire Yes No

LOCATION SKETCH

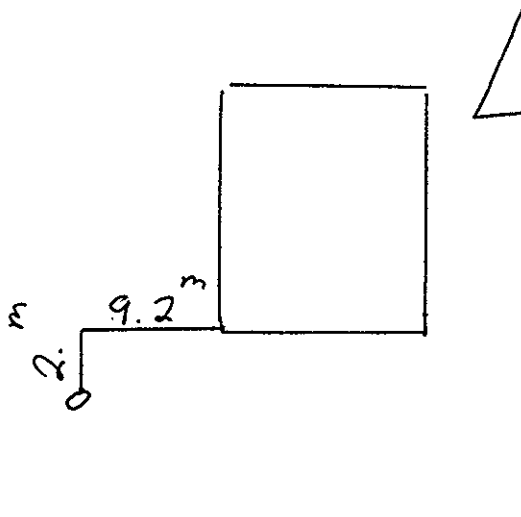

Field Location By G.C. Date 11/6/92.

Checked by: _____