


City of Prince George HISTORY SHEET

082

SHEET NUMBER	N ^o 2284	Roll Number
Legal:	LOT'S 3-4 BLOCK 6 D.L. 937	PLAN 752
Address:	783 HARPER STREET	
Sanitary Connection: #	7595 SIZE 100mm MATERIAL AC INV.	CONNECTED
Water Connection #	7626 SIZE 19mm MATERIAL CU METER	CONNECTED
Storm Connection: #	SIZE MATERIAL INV.	CONNECTED
Cash Receipt No's:	WATER SANITARY 604. STORM	
CURB FROM PROPERTY LINE	4.877m	PAVEMENT WIDTH
B.C. HYDRO	OVERHEAD	UNDERGROUND CONNECTION
B.C. TELEPHONE	OVERHEAD	UNDERGROUND CONNECTION
INLAND GAS	AS SHOWN	
Information Sheets:		
Comments:		

SITE PLAN N.T.S.

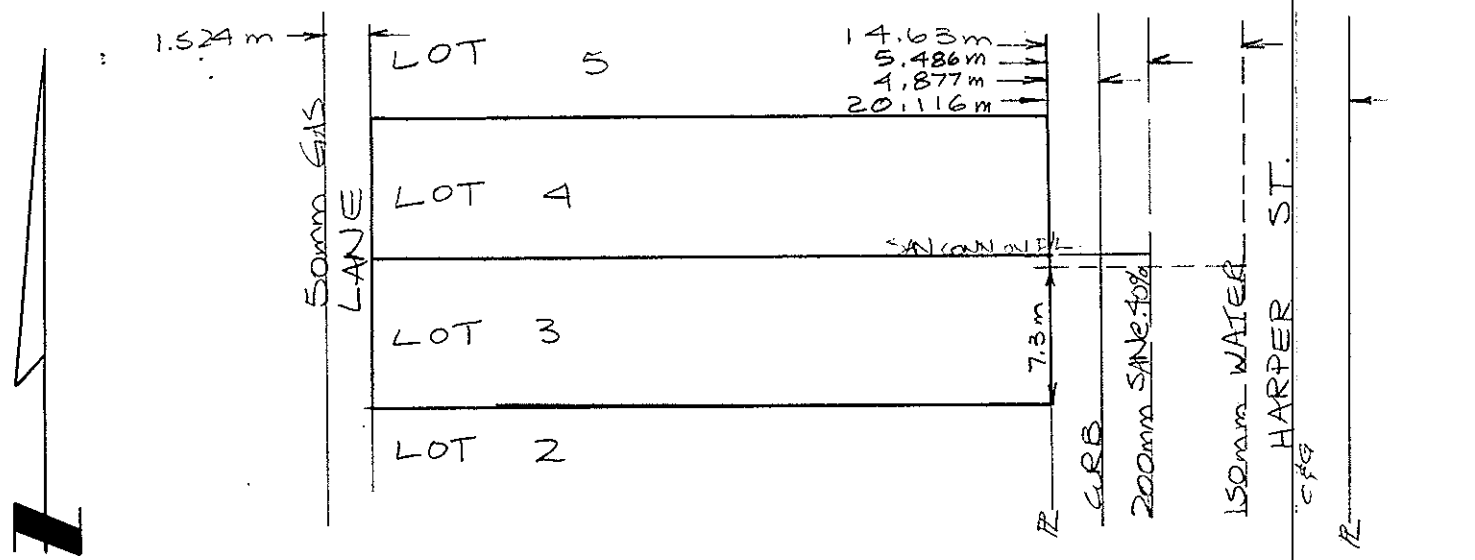

REPORT TO RECORDS

WATER SERVICE INFORMATION

Lot No. _____ Block _____ D.L. _____


Address 783 Harper

Size of Connection 1/2" 3/4" Other _____

Type of Connection Copper Iron

Thaw Wire Yes No

LOCATION SKETCH

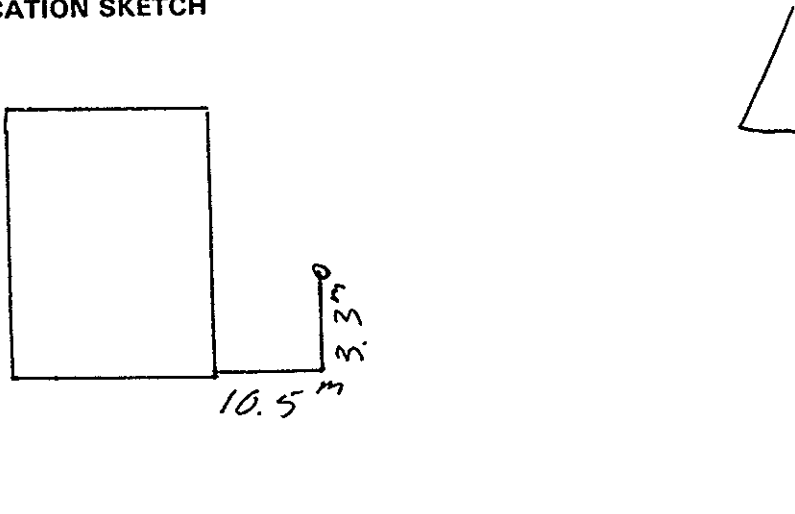

Field Location By G.C. Date 11/6/92

Checked by: _____