

# City of Prince George HISTORY SHEET

SHEET NUMBER **Nº 2270** Roll Number **69900601**

Legal: LOT'S **3-4** BLOCK **36** D.L. **937** PLAN **752**

Address: **571 HARPER STREET**

Sanitary Connection: # **3429** SIZE MATERIAL INV. CONNECTED

Water Connection # **1071** SIZE **13mm** MATERIAL METER CONNECTED

Storm Connection: # SIZE MATERIAL INV. CONNECTED

Cash Receipt No's: WATER SANITARY STORM

CURB FROM PROPERTY LINE **4.877m** PAVEMENT WIDTH

B.C. HYDRO **OVERHEAD** UNDERGROUND CONNECTION


B.C. TELEPHONE **OVERHEAD** UNDERGROUND CONNECTION

INLAND GAS

Information Sheets:

Comments:

SITE PLAN N.T.S.

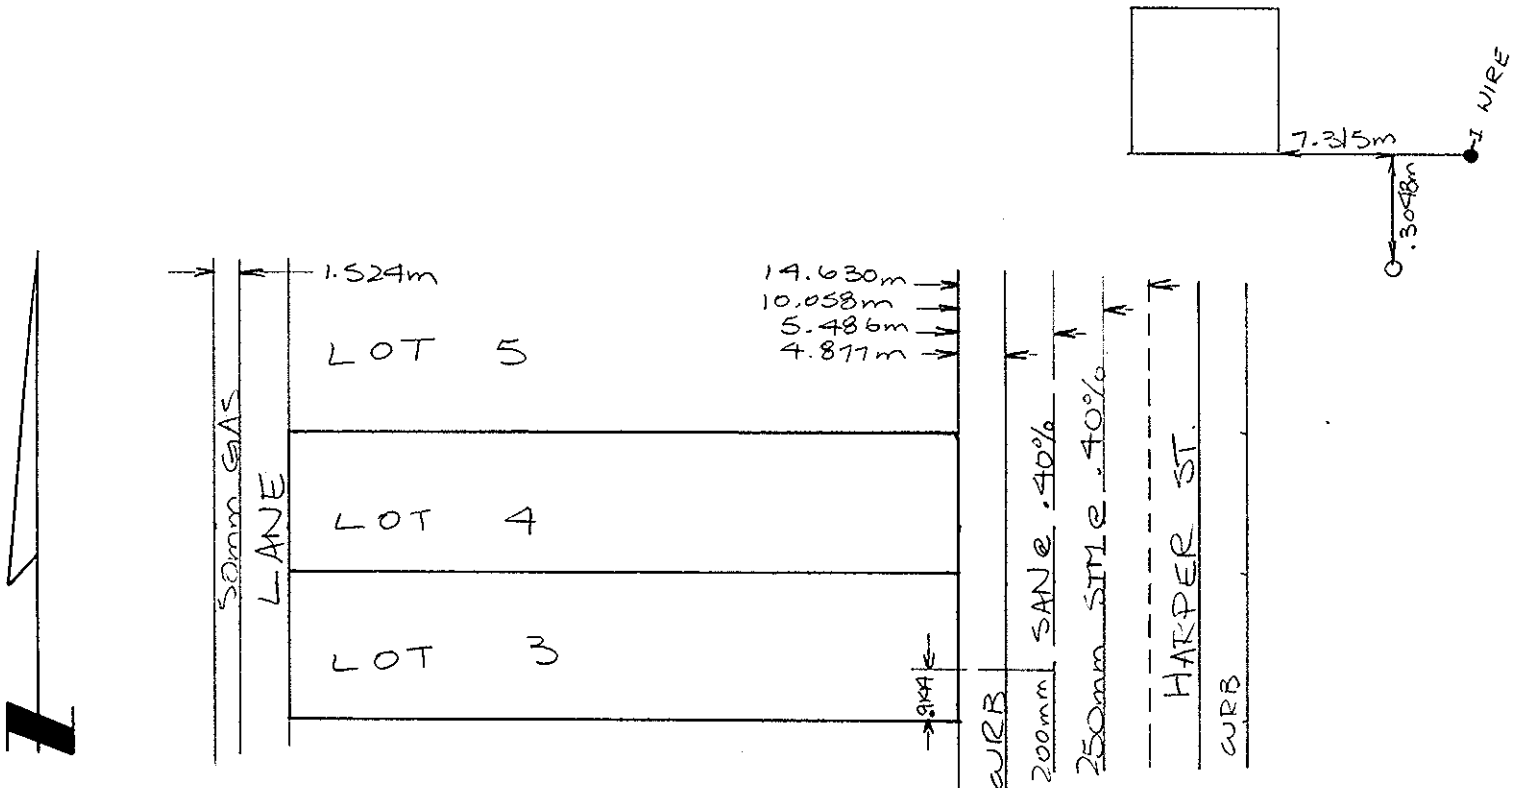


# REPORT TO RECORDS

## WATER SERVICE INFORMATION

Lot No. \_\_\_\_\_ Block \_\_\_\_\_ D.L. \_\_\_\_\_

Address 571 HarperSize of Connection ☐ 1/2" ☐ 3/4" ☐ Other \_\_\_\_\_Type of Connection ☐ Copper ☐ IronThaw Wire ☐ Yes ☐ No

### LOCATION SKETCH

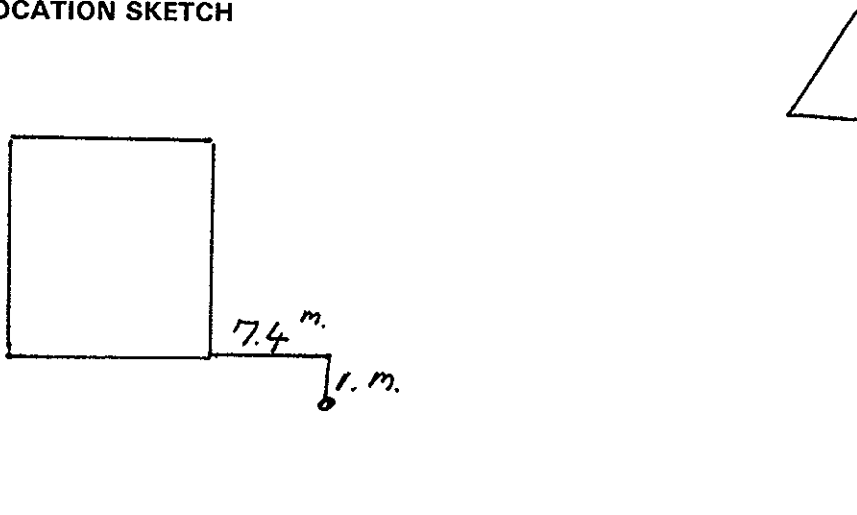Field Location By G.C. Date 9/6/92.

Checked by: \_\_\_\_\_