

City of Prince George HISTORY SHEET

011165146

SHEET NUMBER **Nº 1097** Roll Number **197**

Legal: LOT'S **19-20** BLOCK **37** D.L. **1429** PLAN **646**

Address: **954 IRWIN ST.**

Sanitary Connection: # **4410** SIZE **100mm** MATERIAL **A.C.S.** INV. **CONNECTED**

Water Connection # **1596-4178** SIZE **13mm** MATERIAL **METER** **CONNECTED**

Storm Connection: # **SIZE MATERIAL INV. CONNECTED**

Cash Receipt No's: WATER **2499** SANITARY **2499** STORM

CURB FROM PROPERTY LINE PAVEMENT WIDTH

B.C. HYDRO UNDERGROUND CONNECTION


B.C. TELEPHONE UNDERGROUND CONNECTION

INLAND GAS

Information Sheets:

Comments:

SITE PLAN N.T.S.

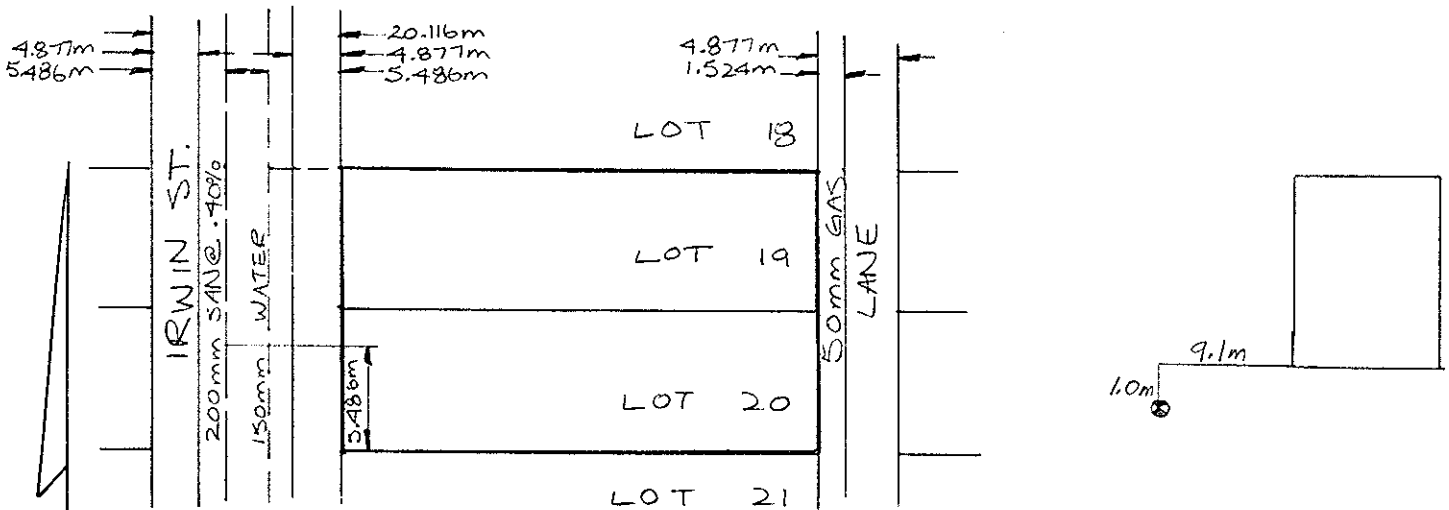


REPORT TO RECORDS

WATER SERVICE INFORMATION

Lot No. _____ Block _____ D.L. _____

Address 954 IrwinSize of Connection ☐ 1/2" ☐ 3/4" ☐ Other _____Type of Connection ☐ Copper ☐ IronThaw Wire ☒ Yes ☐ No

LOCATION SKETCH

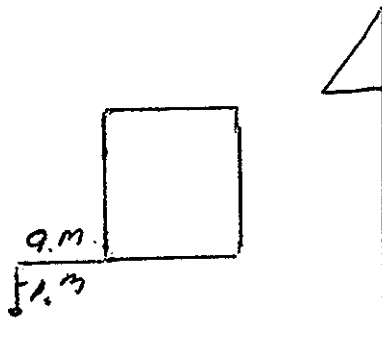Field Location By _____ Date 6/8/92

Checked by: _____