

015936333
015936368
015936376
015936384

015936392
015936406
015936431
015936422

Update requested 2021
- CFS 349084

City of Prince George
HISTORY SHEET

015936449
015936511
012994669
012994677

012994685
For PIDs, see
next page

See attached

SHEET NUMBER _____ Roll Number _____

Legal: LOT'S ~~1-20, 1-20-1-13~~ BLOCK ~~143-145~~ D.L. 343 PLAN 1268

Address: ~~Public Works Yard - 4th Ave~~ 433 4th Ave

Sanitary Connection: # 7570, 9872 (4") (4") SIZE 1" MATERIAL A.C. INV. _____ CONNECTED ☒

Water Connection # 4981, 9872 (1 1/2") SIZE 2" / 1 1/2" MATERIAL CU. METER _____ CONNECTED ☒

Storm Connection: # _____ SIZE 200mm MATERIAL _____ INV. _____ CONNECTED n/c

Cash Receipt No's: WATER 1274 SANITARY 1274 STORM 1274

CURB FROM PROPERTY LINE 10' PAVEMENT WIDTH 48'


B.C. HYDRO 0/H UNDERGROUND CONNECTION _____

B.C. TELEPHONE 0/H UNDERGROUND CONNECTION _____

INLAND GAS 10' 4th Ave 1 1/4" @ m

Information Sheets:

Comments: San. Con. No's 1171-1172 given on old history sheet for Block 145, but couldn't find any divg. showing a connection.

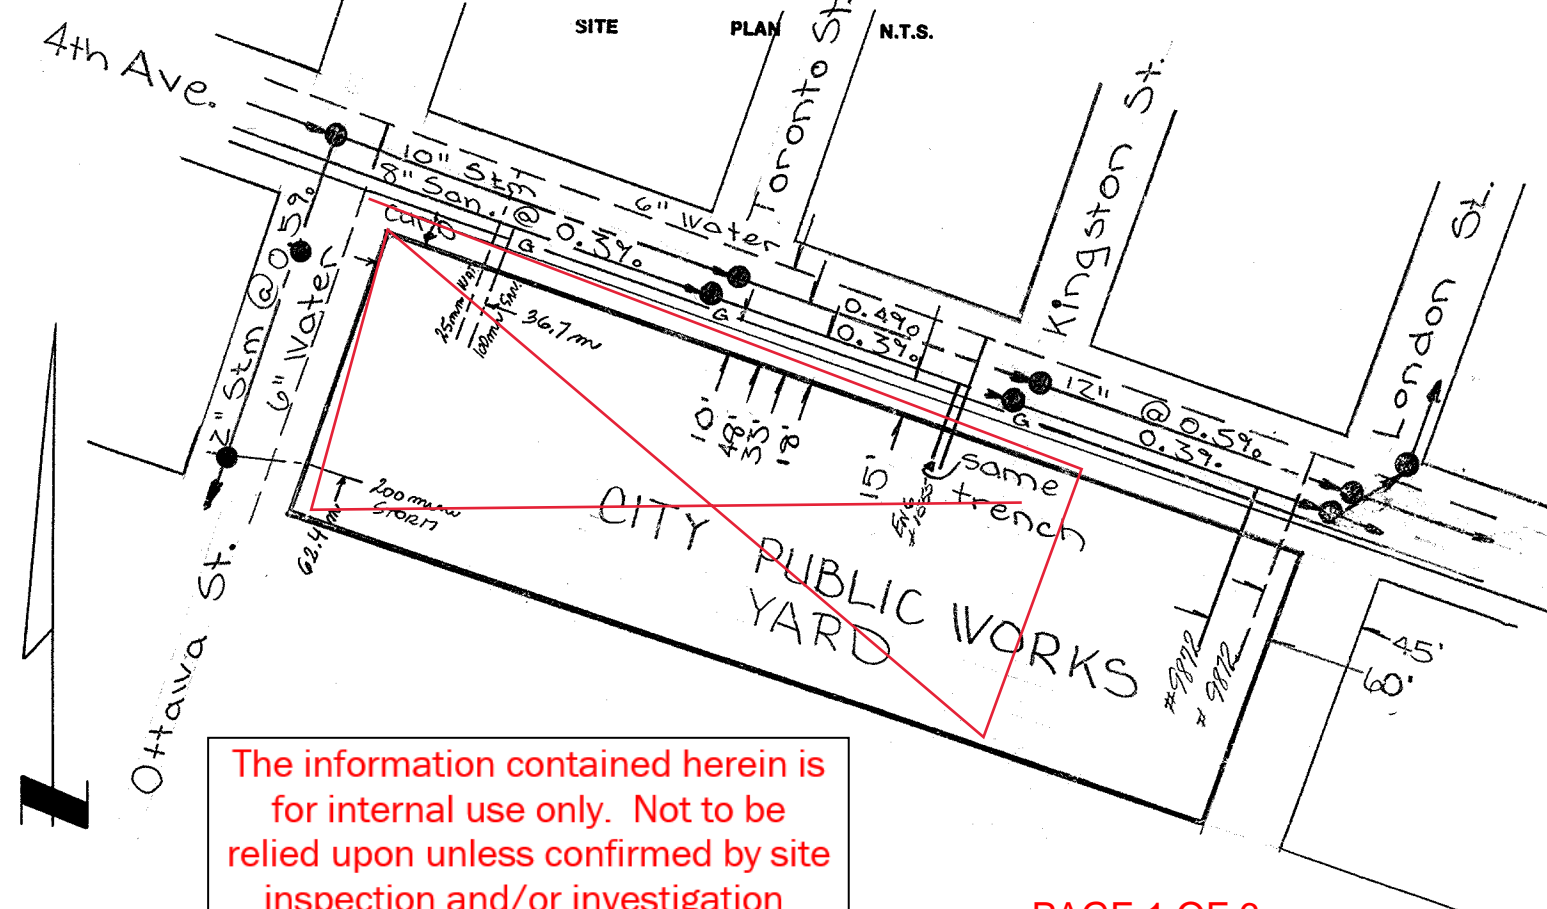

The information contained herein is for internal use only. Not to be relied upon unless confirmed by site inspection and/or investigation.

BLOCK 145**505 4th Ave**

007796510 Lot 6

013042157 Lot 7

007796536 Lot 8

007796561 Lot 11

007796579 Lot 12

007796609 Lot 13

007796617 Lot 14

007796625 Lot 15

597 4th Ave

013023845 Lot 9

013023861 Lot 10

LOT A PLAN**EPP56461****693 4th Ave**

029807981

BLOCK 144**505 4th Ave**

007796692 Lot 1

007796706 Lot 2

007796714 Lot 3

007796722 Lot 4

007796731 Lot 5

007796633 Lot 6

007796650 Lot 7

007796676 Lot 8

015936554 Lot 9

015936589 Lot 10

015936597 Lot 11

015936601 Lot 12

010193774 Lot 13

015936619 Lot 14

015936627 Lot 15

015936635 Lot 16

015936643 Lot 17

015936651 Lot 18

015936660 Lot 19

015936678 Lot 20

BLOCK 143**433 4th Ave**

015936333 Lot 1

015936368 Lot 2

015936376 Lot 3

015936384 Lot 4

015936392 Lot 5

015936406 Lot 6

015936422 Lot 7

015936431 Lot 8


015936449 Lot 9

015936511 Lot 10

012994669 Lot 11

012994677 Lot 12


012994685 Lot 13

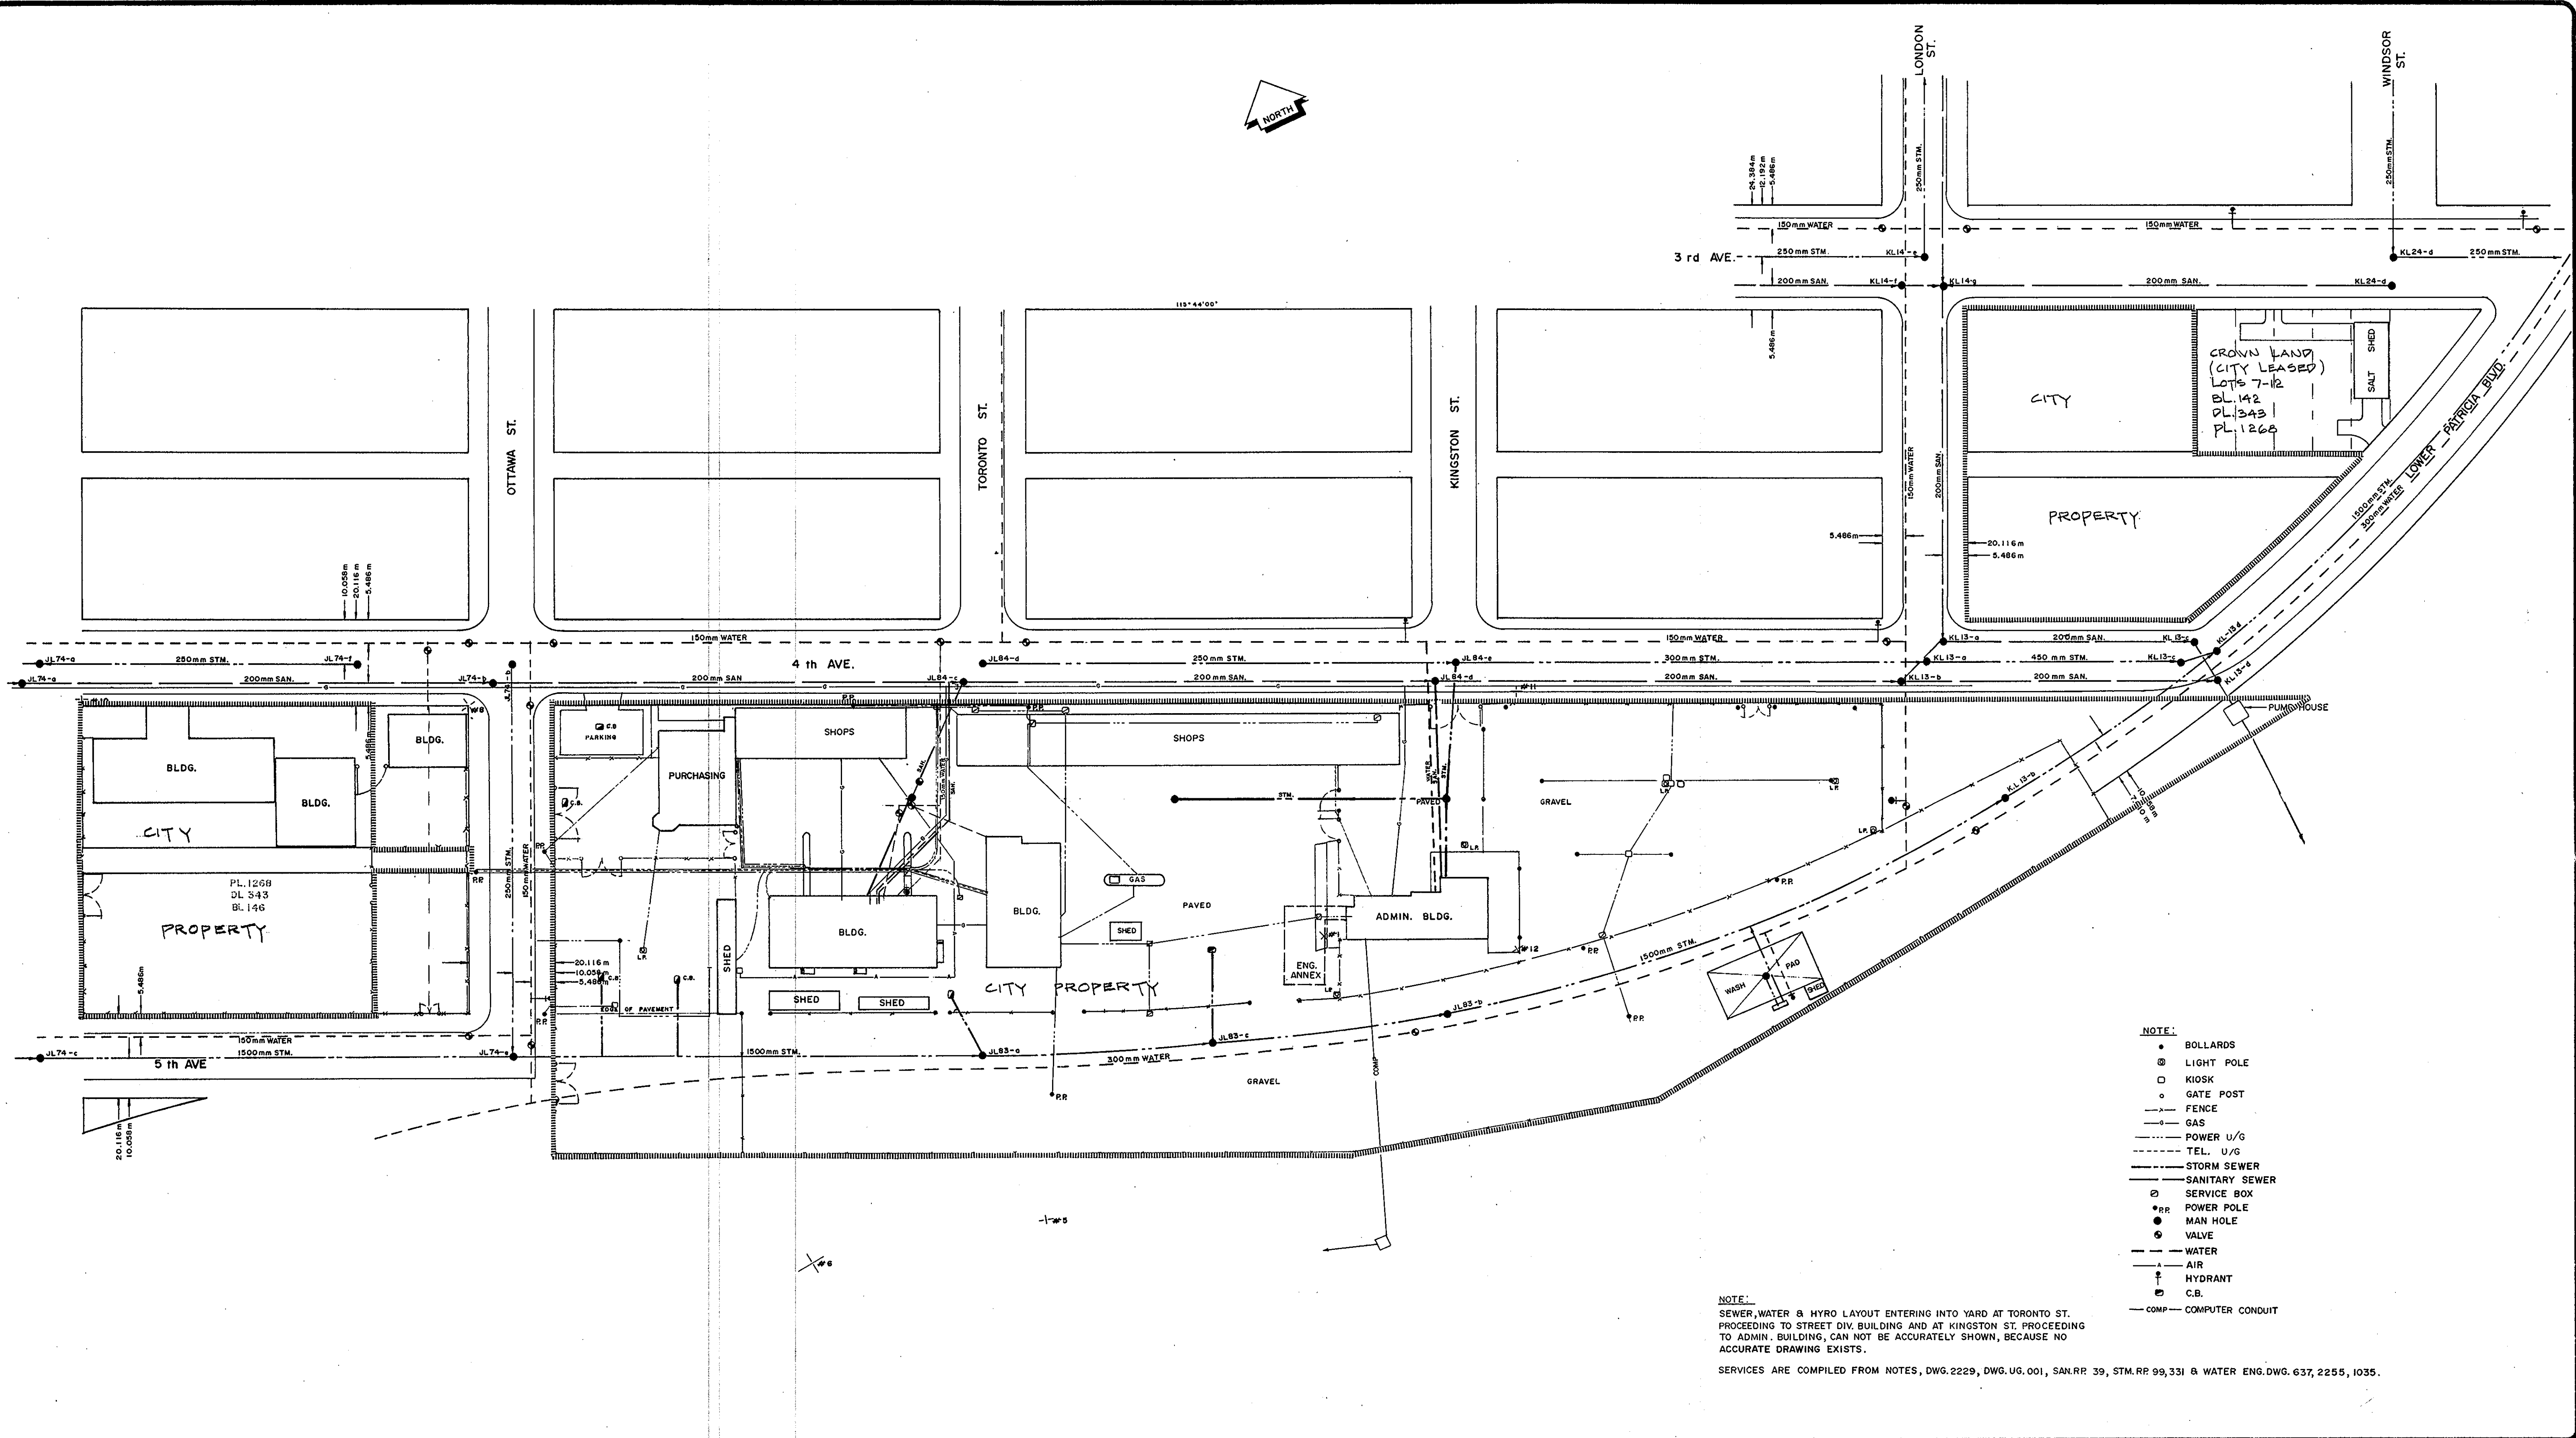


NOTE:
SEWER, WATER & HYDRO LAYOUT ENTERING INTO YARD AT TORONTO ST.
PROCEEDING TO STREET DIV. BUILDING AND AT KINGSTON ST. PROCEEDING
TO ADMIN. BUILDING, CAN NOT BE ACCURATELY SHOWN, BECAUSE NO
ACCURATE DRAWING EXISTS.
SERVICES ARE COMPILED FROM NOTES, DWG. 2229, DWG. UG. 001, SAN. RR. 39, STM. RR. 99, 331 & WATER ENG. DWG. 637, 2255, 1035.

The City of Prince George does not represent or guarantee that the information contained in this document is accurate or reliable, and any person who relies on this information in this document does so at his / her own risk.

REVISIONS				
No.	DATE	BY	SUBJECT	

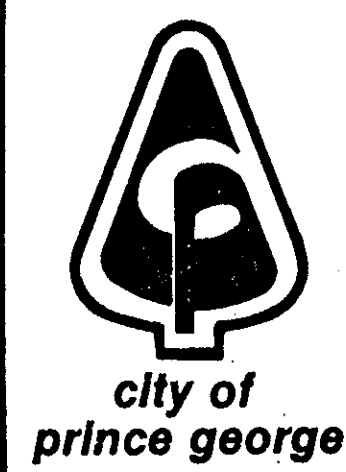

CITY OF PRINCE GEORGE PUBLIC WORKS DEPARTMENT		
CITY OF PRINCE GEORGE PUBLIC WORKS YARD FACILITIES, UG-POWER, TEL. AND OTHER SERVICES.		
DRAWN: K.H.L.	TRACED:	CHECKED:
VERT. HOR. 1:750	DATE: OCT. 12, 1990	DWG. No. 2685-E
SCALES	CITY ENGINEER	

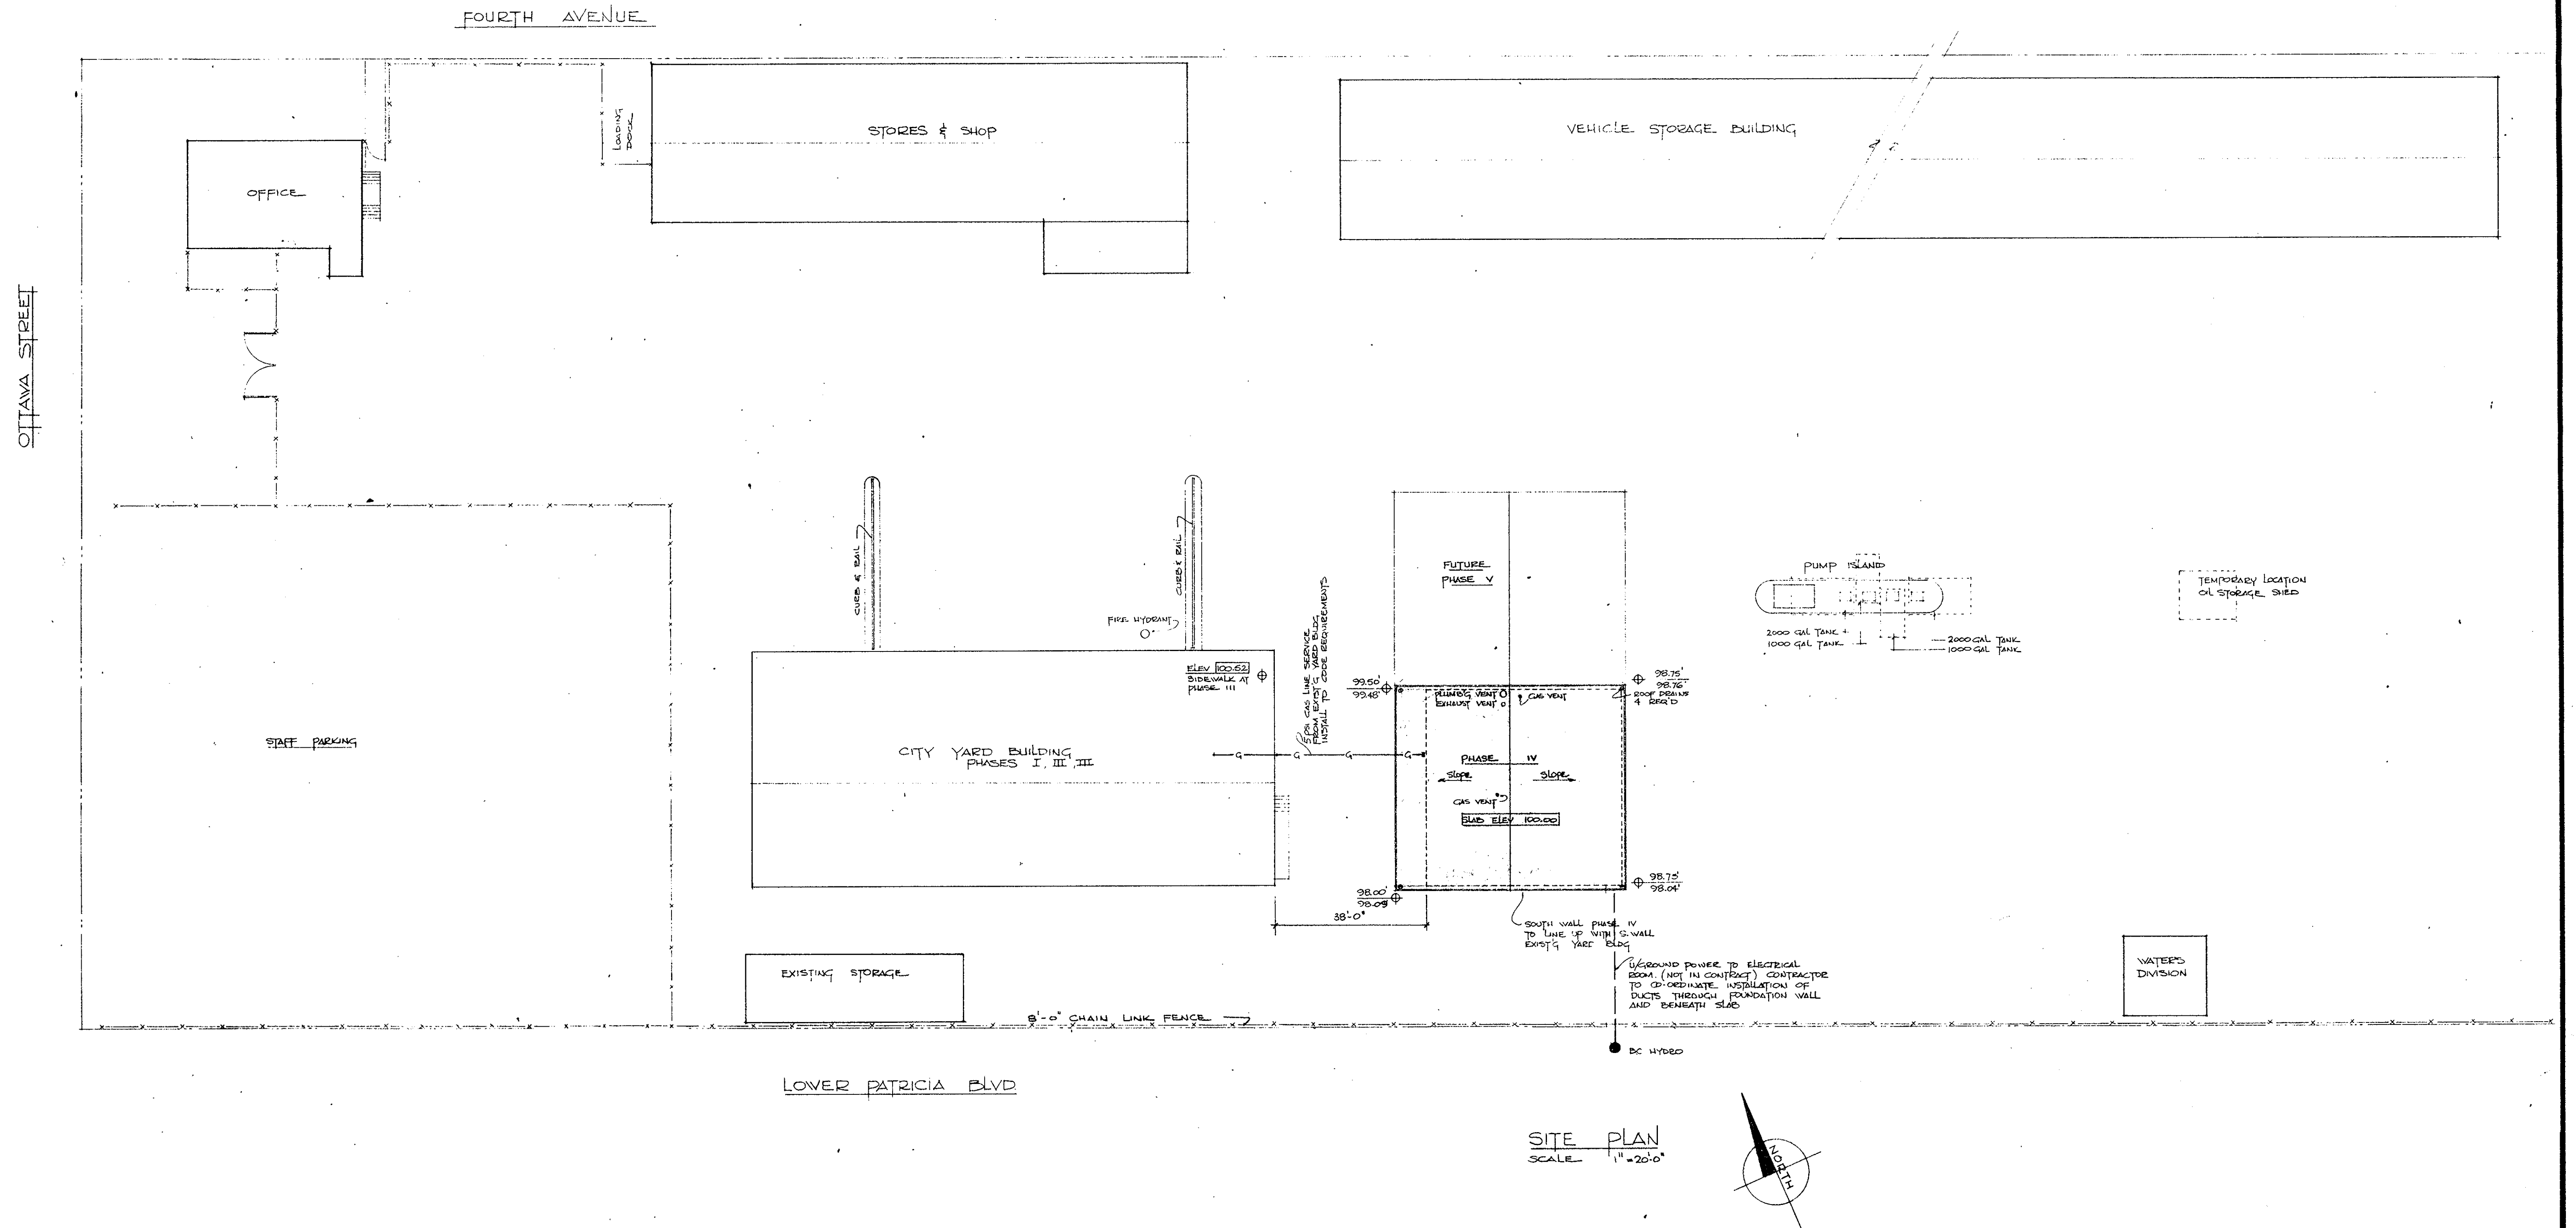

SITE PLAN
SCALE 1" = 20'-0"

LEGAL DESCRIPTION
Lots 1-20
BLOCKS 143, 144, 145
DL 343
PLAN 1268

LEGEND

⊕ FINAL ELEV
○ EXIST'G ELEV

The City of Prince George does not represent or guarantee that the information contained in this document is accurate or reliable, and any person who relies on this information in this document does so at his / her own risk.

CITY YARD BUILDING - Phase IV

CITY OF PRINCE GEORGE

SCALE
1" = 20'-0"

SITE PLAN

DRAWN BY
LKH

CHECKED BY

DATE
2 Sept 75

JOB NO
75 - 100

TOM WEST - ARCHITECT

B. ARCH., M.R.A.I.C.

PRINCE GEORGE, B.C. TEL. 564-8949


ENG. DWG.—

2215

A1


OIL INTERCEPTOR PLAN VIEW

SCALE 1/2" = 1'-0"

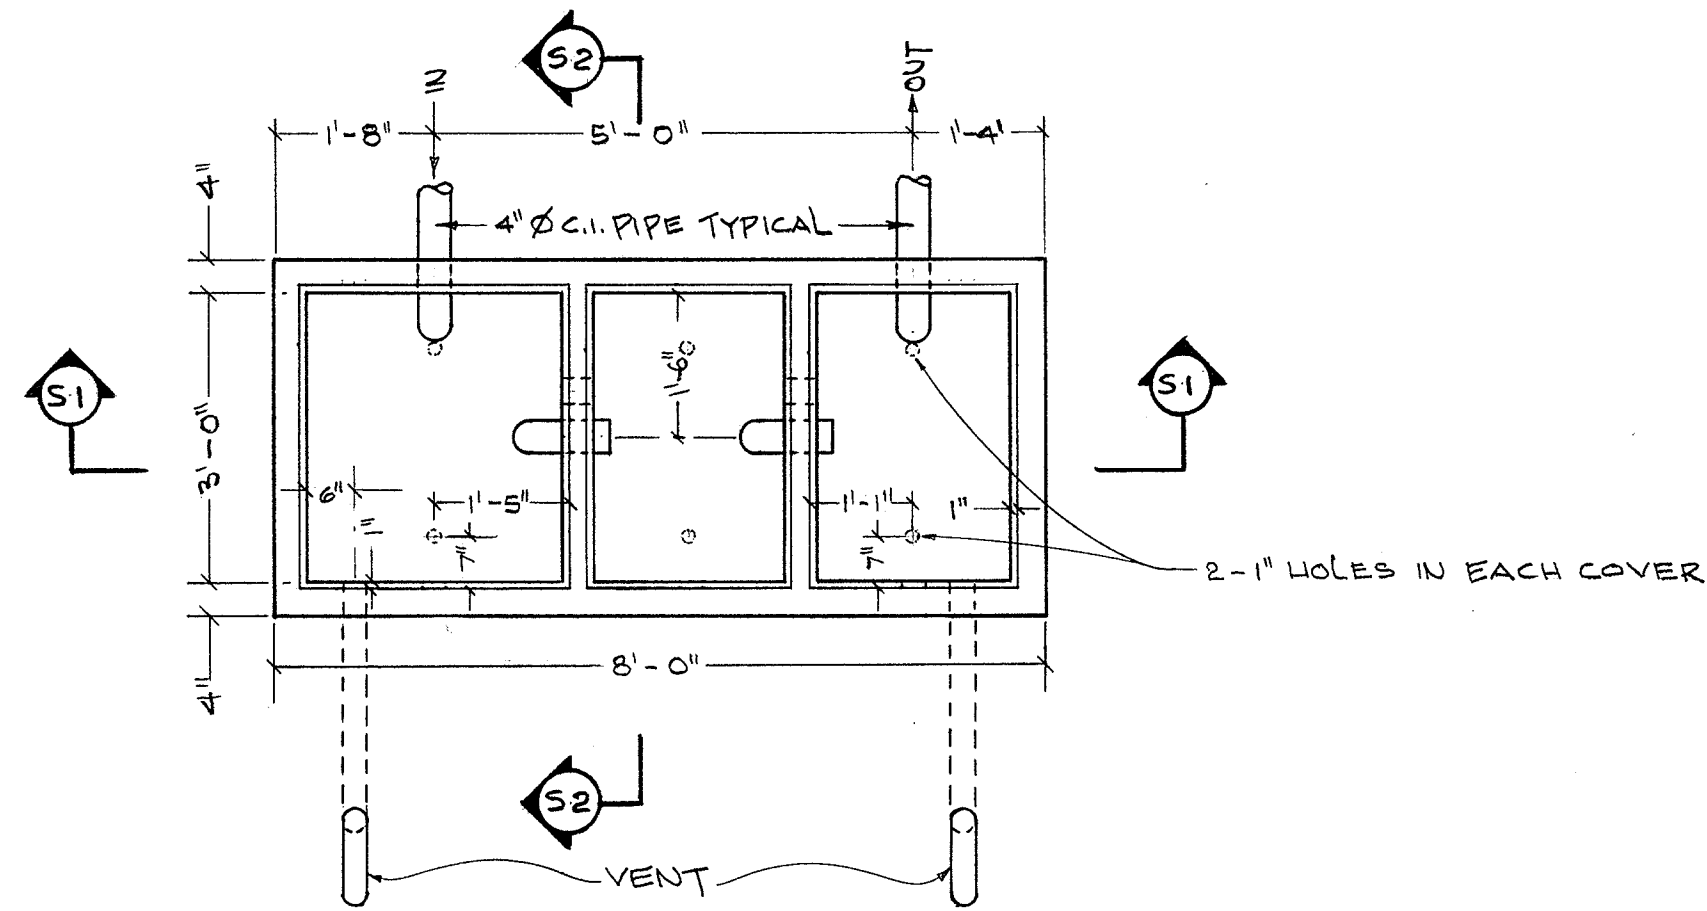



SECTION ①

SCALE 1/2" = 1'-0"

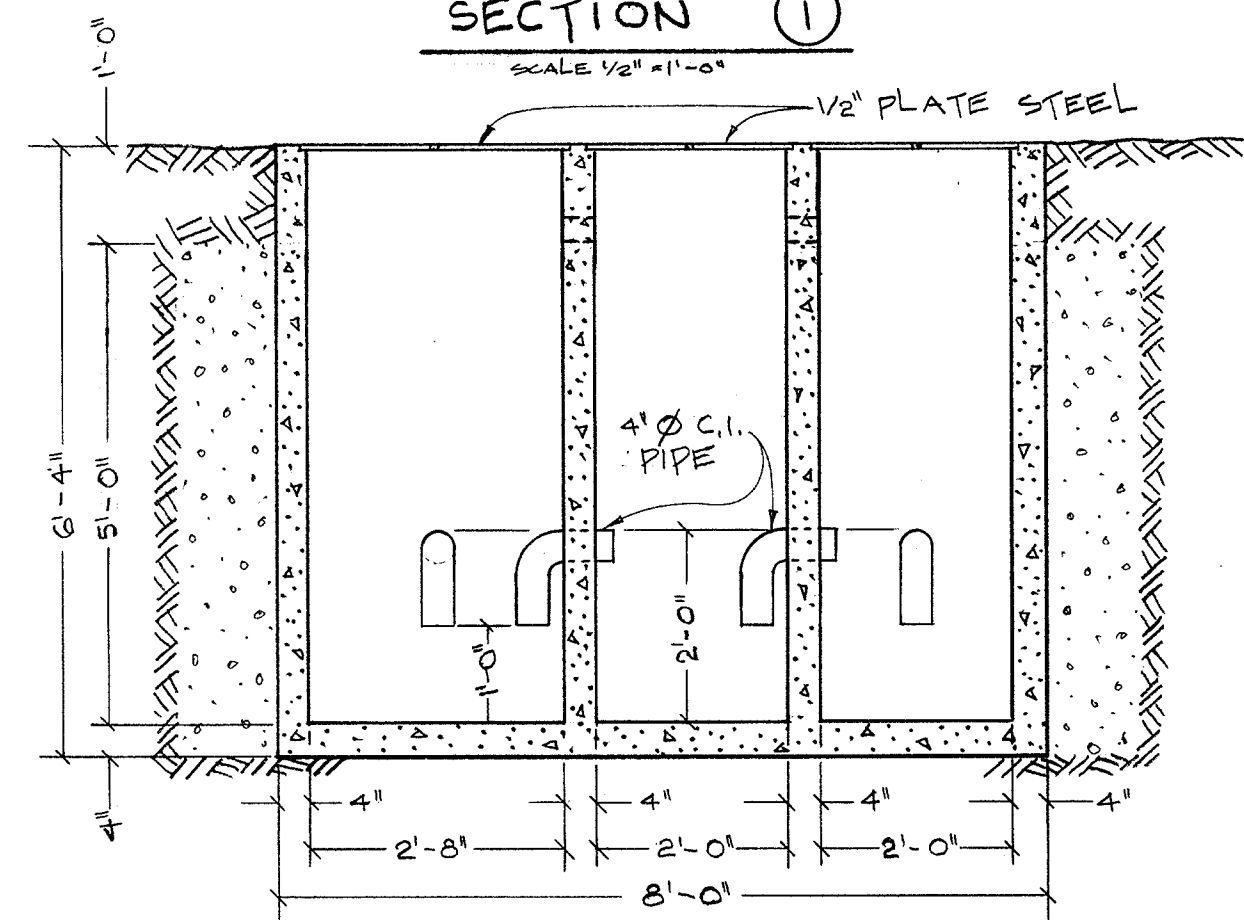

SECTION ②

SCALE 1/2" = 1'-0"

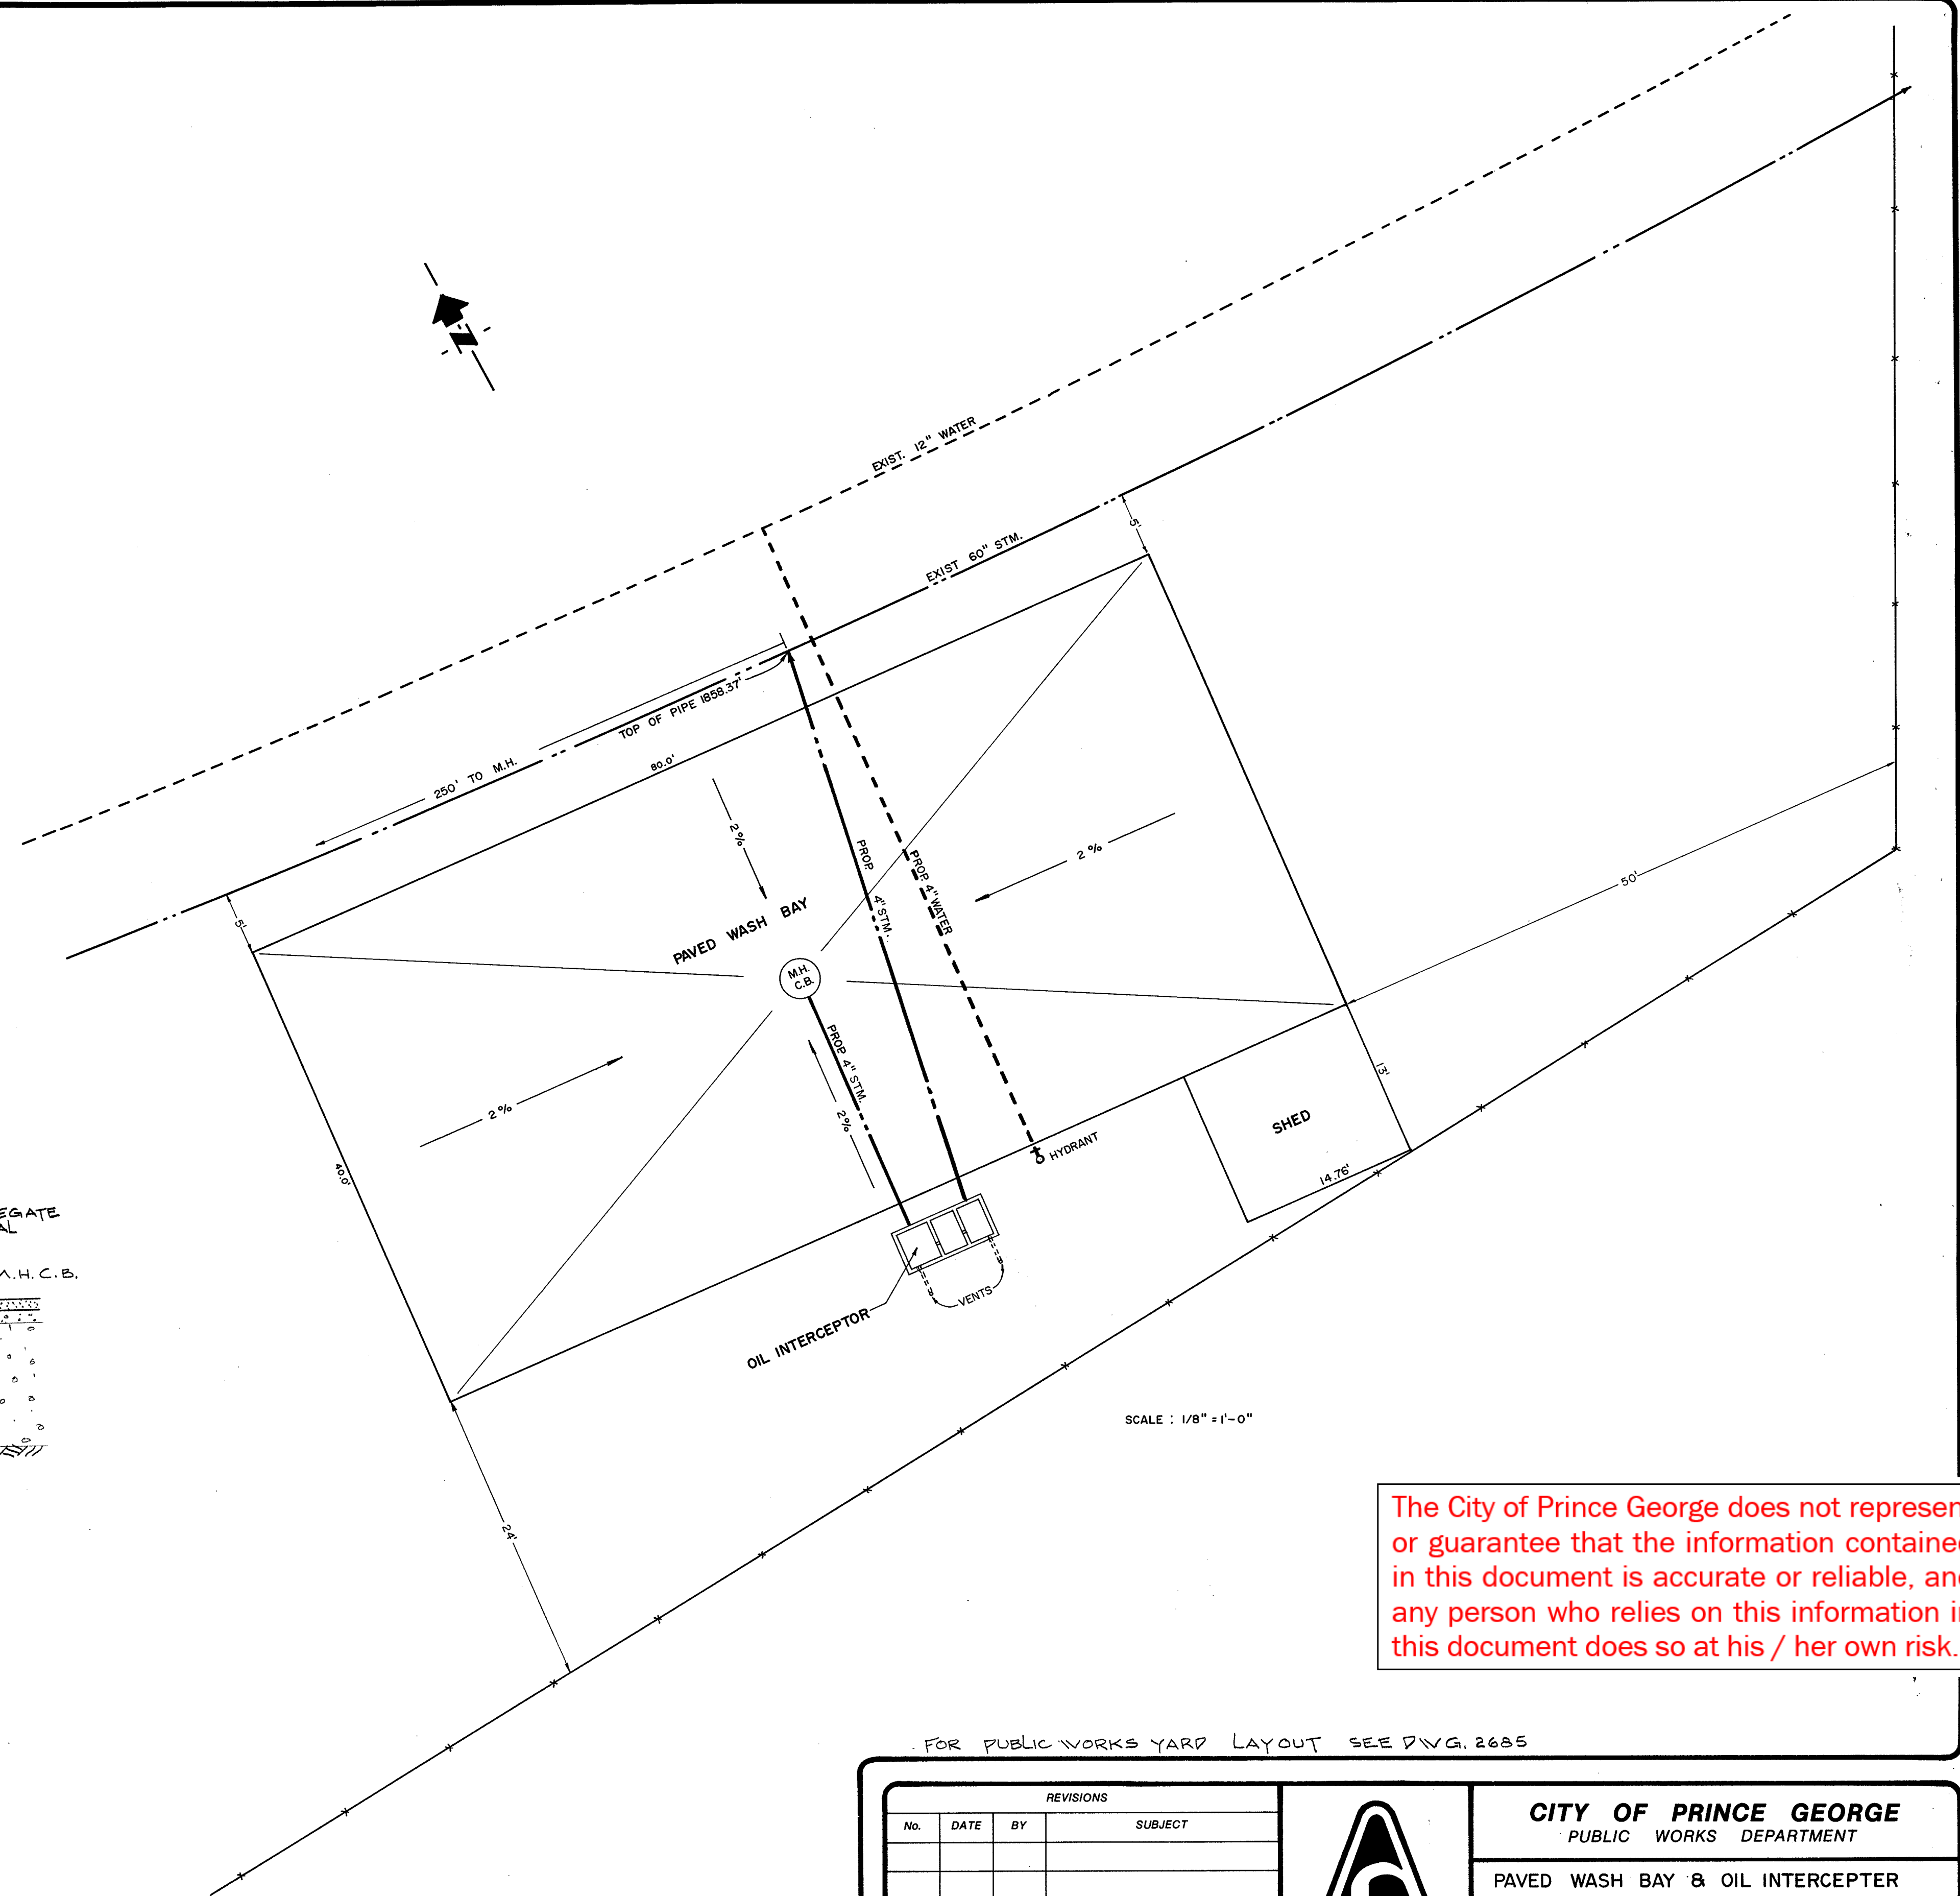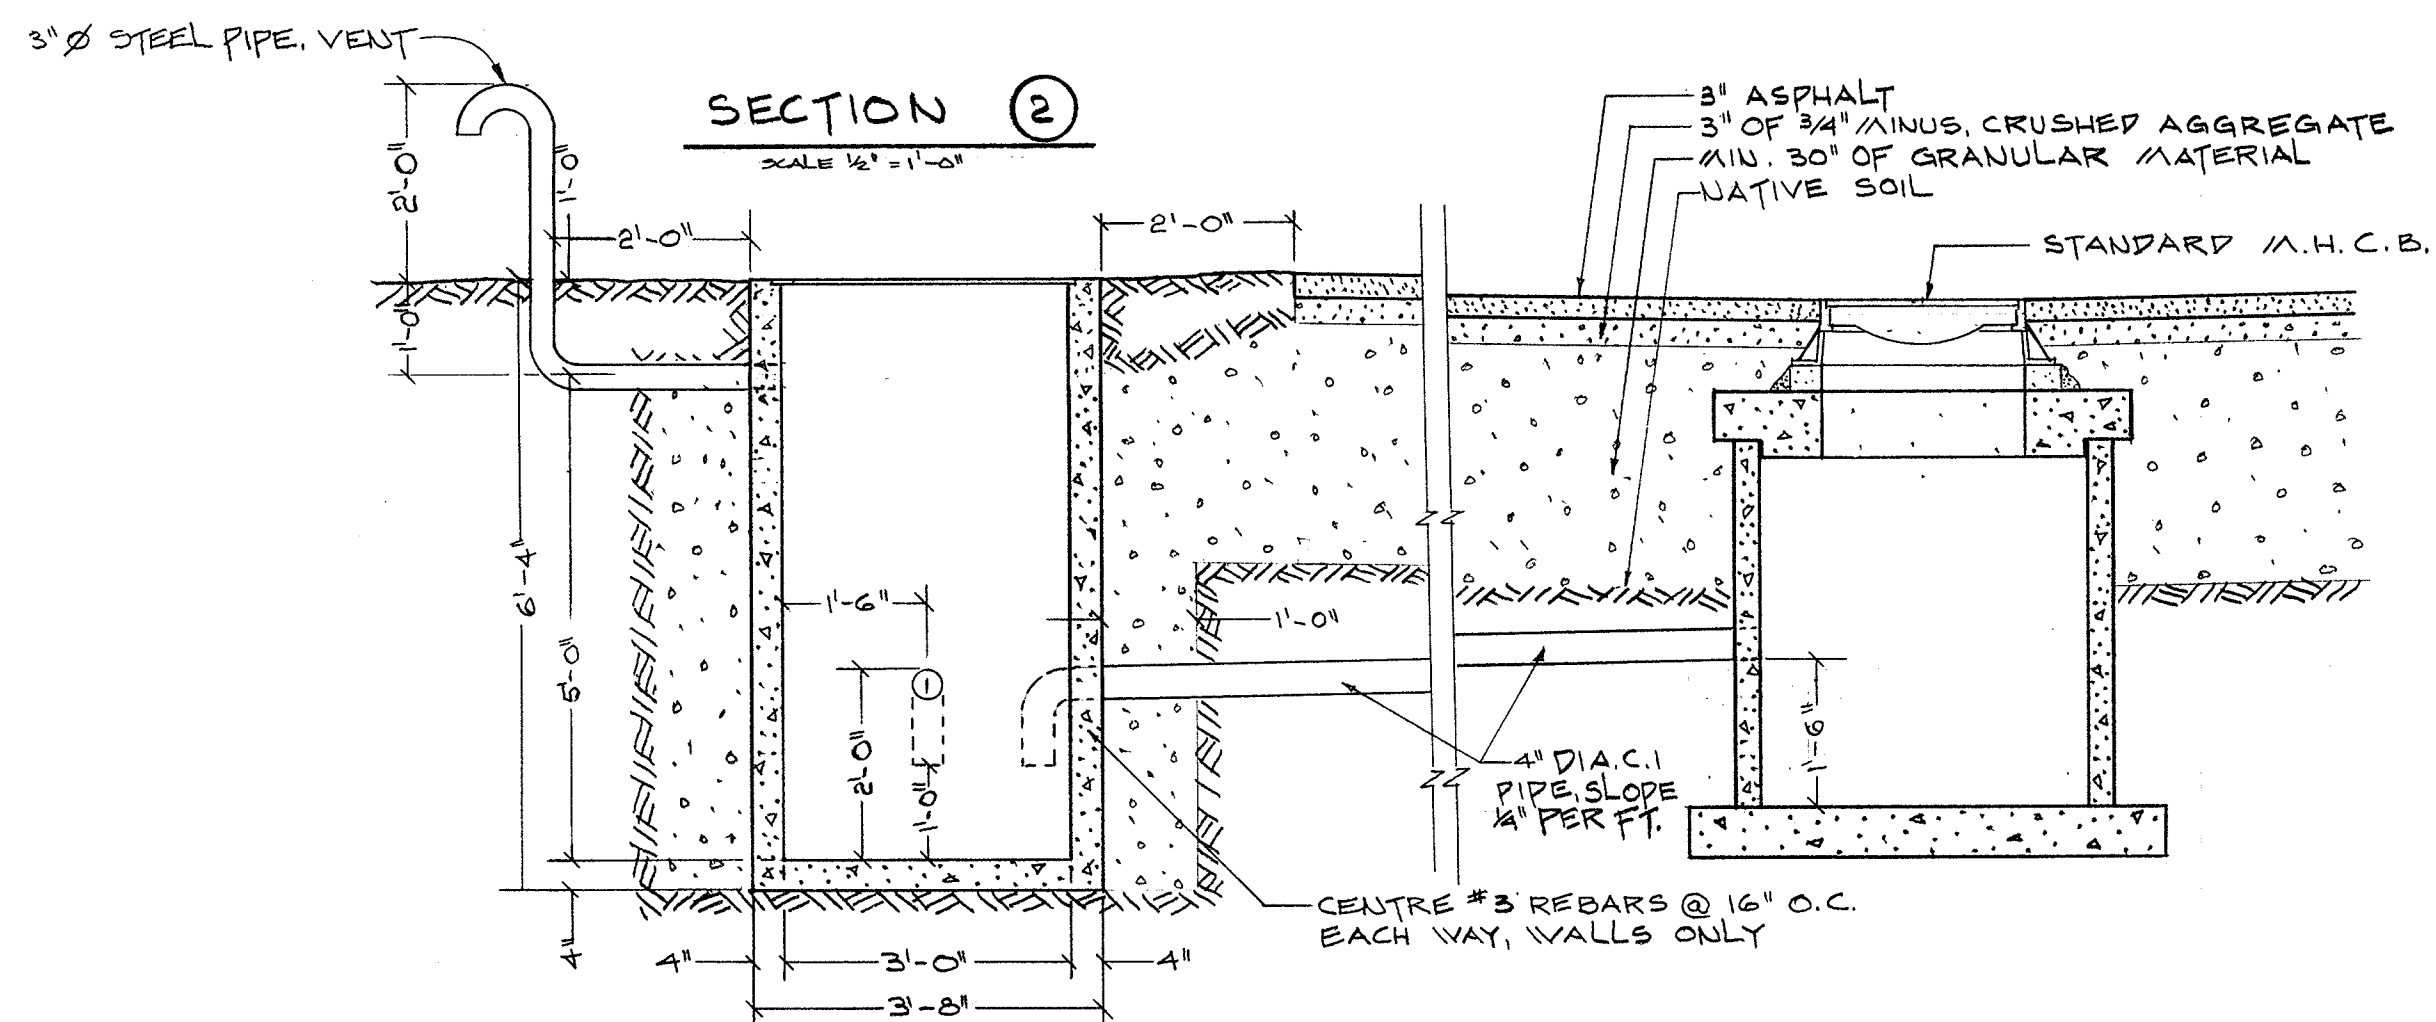


SCALE : 1/8" = 1'-0"

The City of Prince George does not represent or guarantee that the information contained in this document is accurate or reliable, and any person who relies on this information in this document does so at his / her own risk.

FOR PUBLIC WORKS YARD LAYOUT SEE DWG. 2685


REVISIONS				
No.	DATE	BY	SUBJECT	

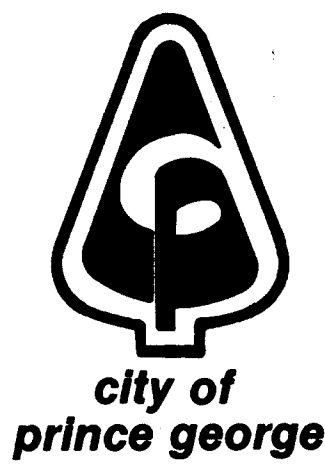

CITY OF PRINCE GEORGE
PUBLIC WORKS DEPARTMENT

PAVED WASH BAY & OIL INTERCEPTOR
FOR PUBLIC WORKS
YARD

DRAWN: K.H.L. TRACED: CHECKED: [Signature]
VERT. DATE: 22.10.1982
HORAS SHOWN DWG. No. 3577
SCALES CITY ENGINEER

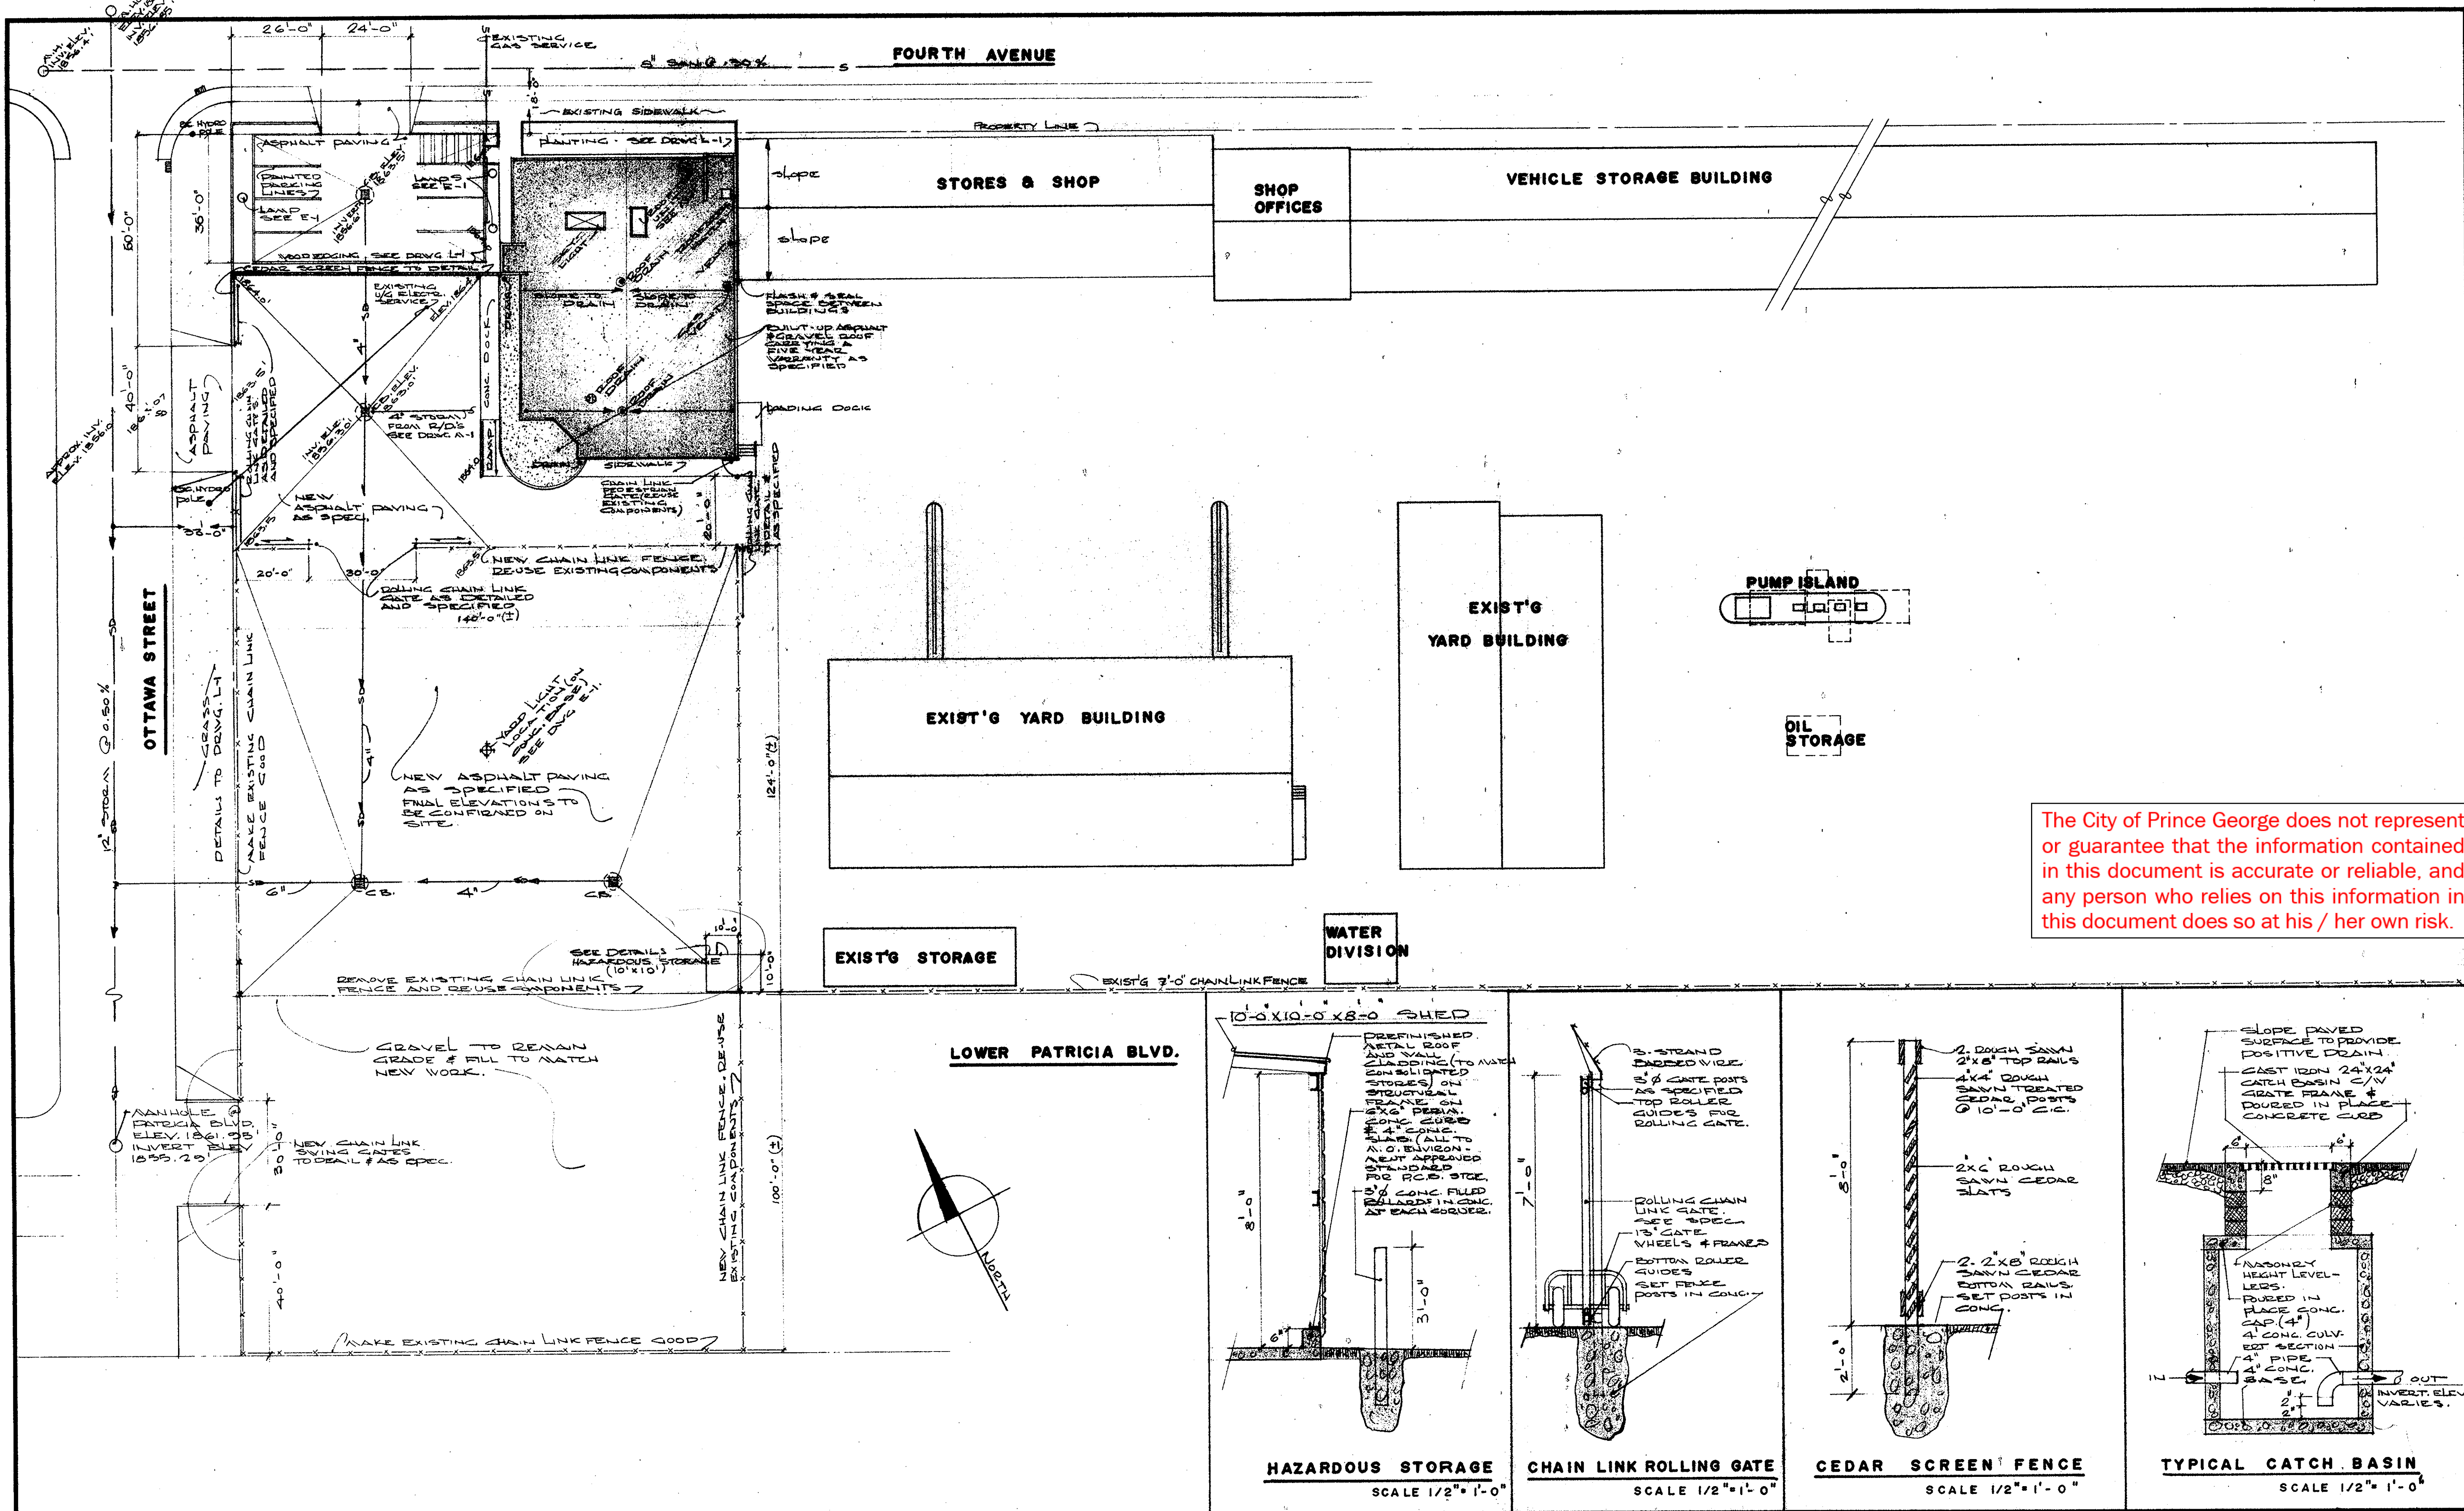

The City of Prince George does not represent or guarantee that the information contained in this document is accurate or reliable, and any person who relies on this information in this document does so at his / her own risk.